


- NOTES**
1. Verifying Dimensions.
Dimensions shall be verified against such other drawings or site conditions as pertain to this part of the work.
 2. Existing Services.
Any information concerning the location of existing services indicated on this drawing is intended for general guidance only.
 3. Datum. Ordnance Datum Malin (unless noted otherwise)
 4. ESB refers to Electricity Service Board
CD refers to Chart Datum
OD refers to Ordnance Datum Malin
 5. Refer to CP1901-3FM-RPS-S45-04-DR-C-0423 for Overall Demolition Plan
 6. For section locations refer to CP1901-3FM-RPS-S45-04-DR-C-0401 to 0404
 7. Proposed Drainage Layout refer to CP1901-3FM-RPS-S45-04-DR-C-0416 to 0419
 8. Proposed Surfacing Details
CP1901-3FM-RPS-S45-04-DR-C-0412 to 415

- Planning Boundary under this application
- Existing Plant to be demolished

Key Plan Showing Section Locations [1:2500]

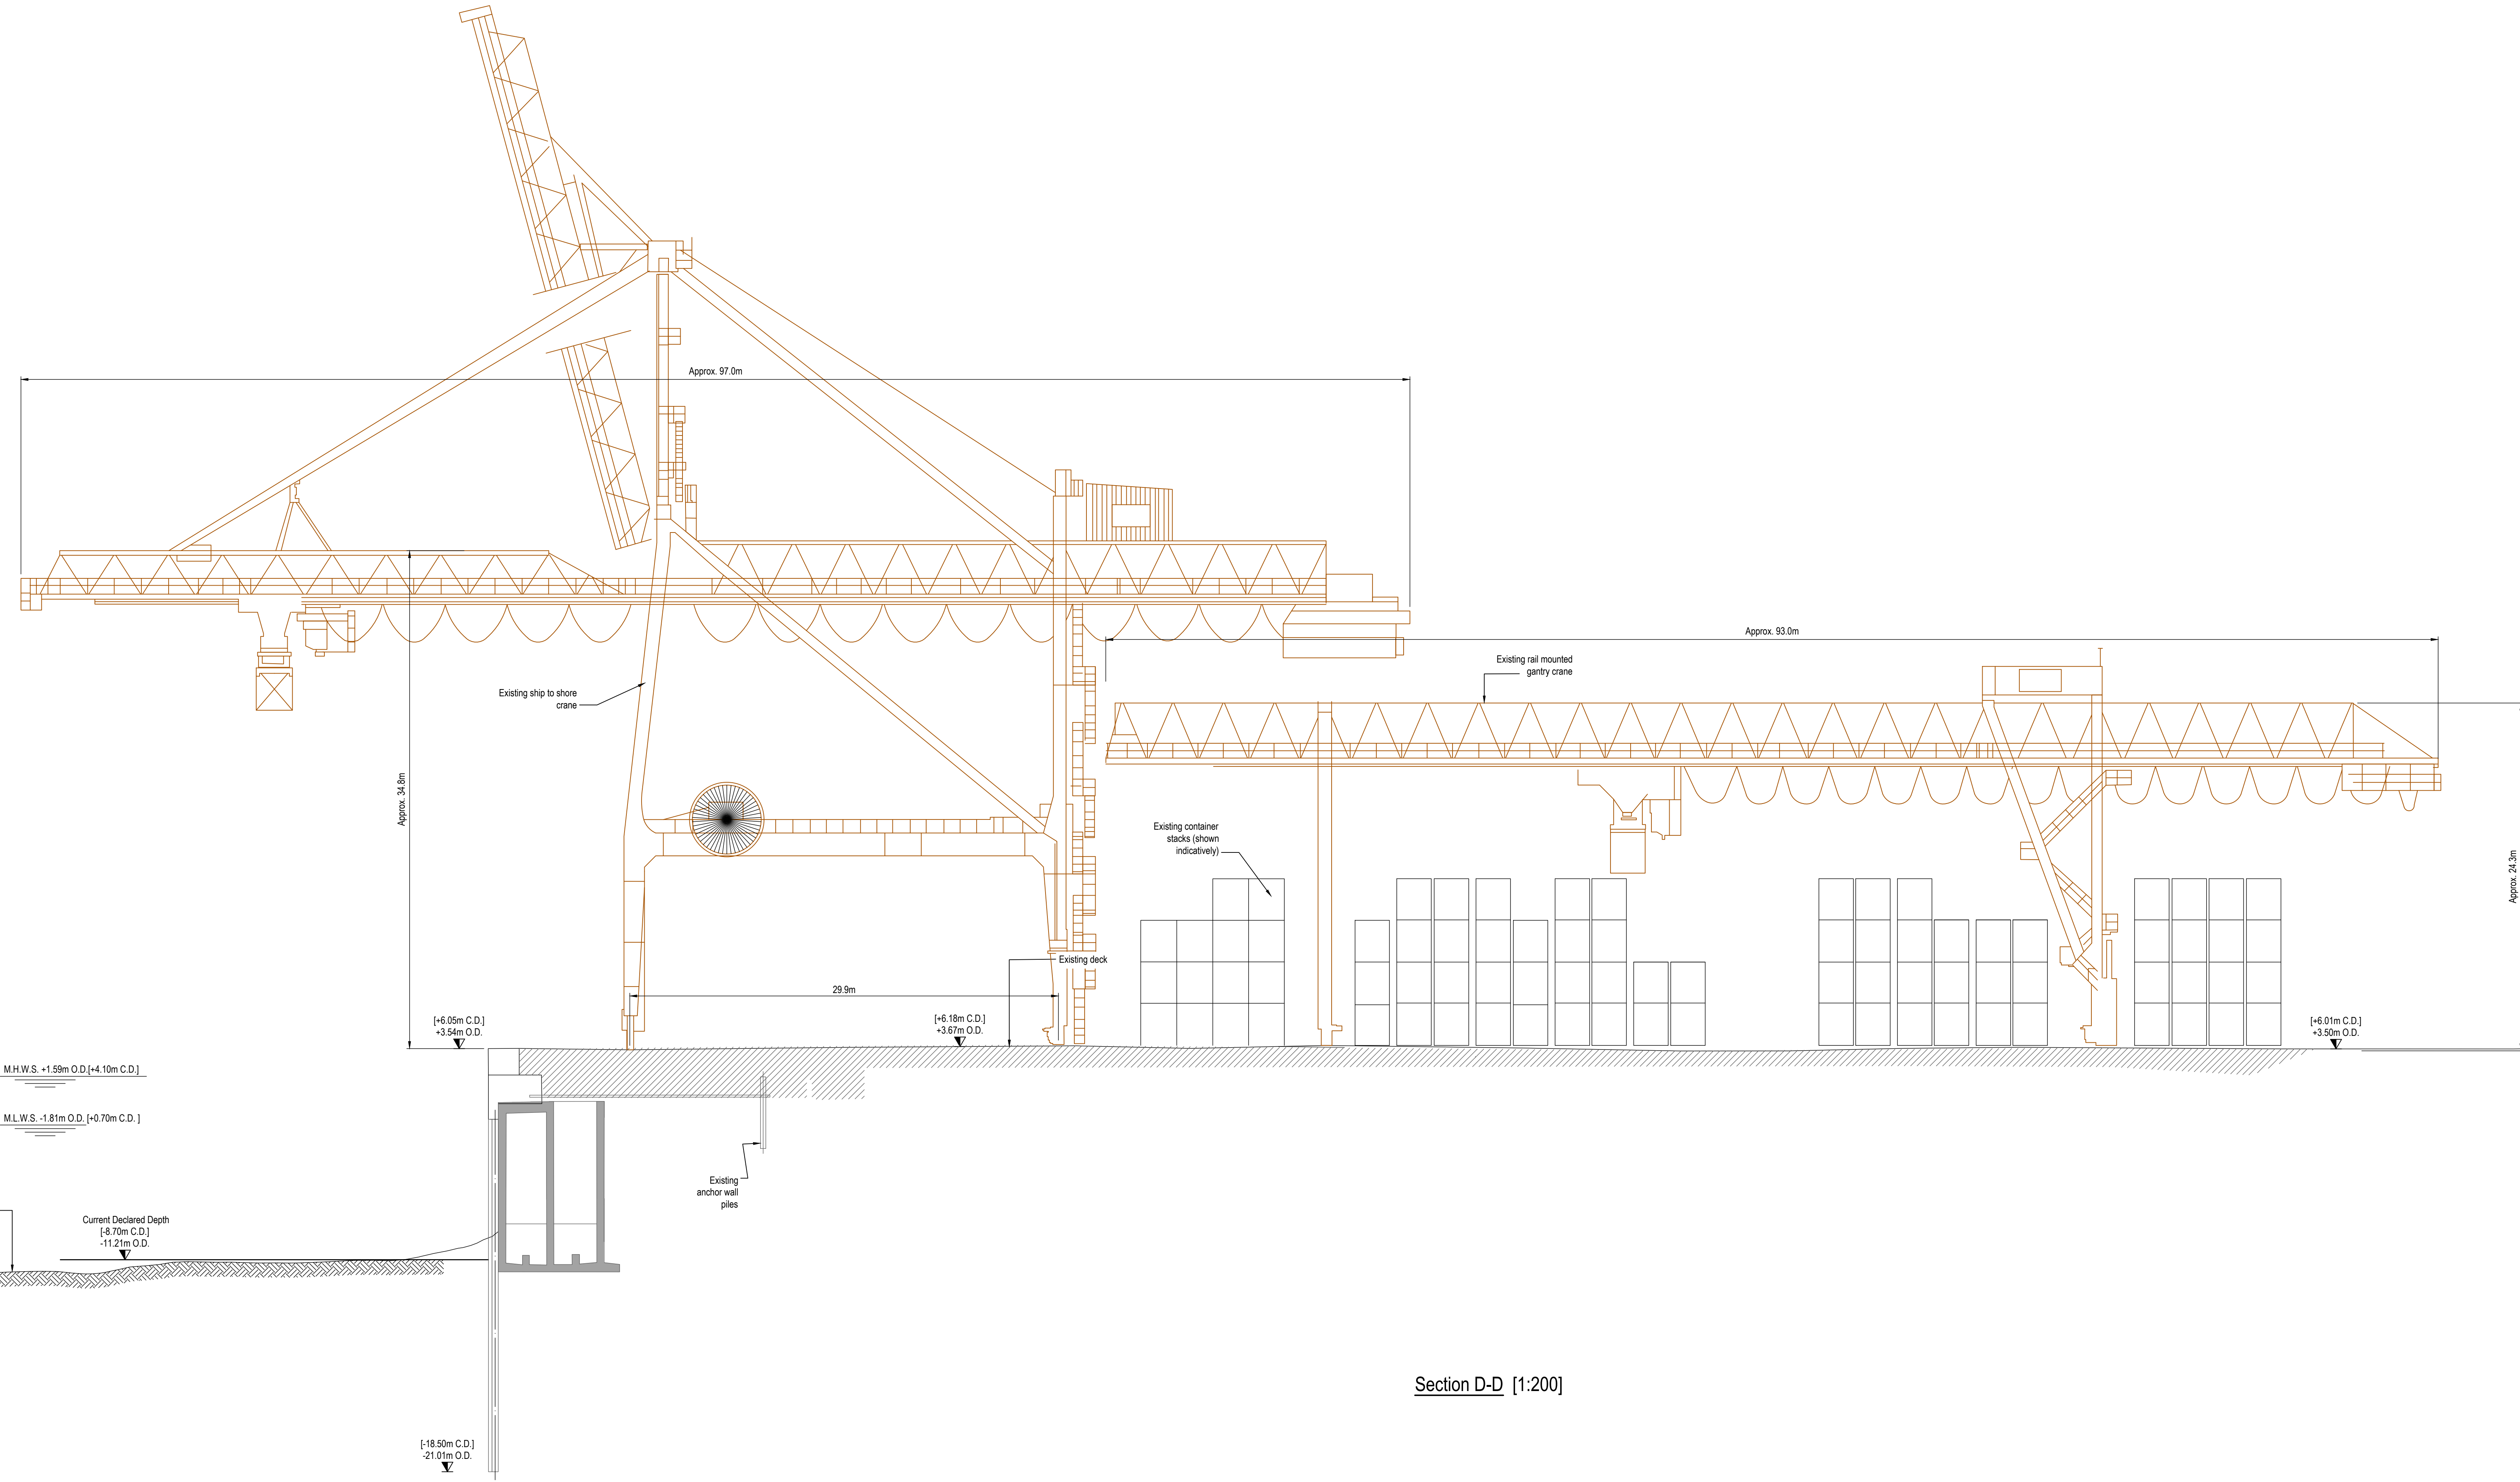

Section D-D [1:200]

PM	Revised for Planning Issue	M.H.	28/06/2024
rev	amendments	check	date
<p>Elmwood House T +44 (0) 28 90 667014 74 Boucher Road F +44 (0) 28 90 666286 Belfast W www.rpsgroup.com/ireland BT1 2 6JZ E ireland@rpsgroup.com</p>			
<p>Client</p>			
<p>Project</p>			
<p>Title</p> <p>Ro-Ro Terminal (Area K) Existing Typical Cross Sections B-B</p>			
Project Number	Sheet Size	Drawing Scale	
IBM0842	A0	As Shown	
<p>Drawing Number</p> <p>CP1901-3FM-RPS-S45-04-DR-C-0402</p>			
Drawn By	Status	Revision	
M.H.	S4	P04	
Checked By	Approved By	Date	
E.H.	M.McC.	19/12/2022	