



- NOTES**
1. Verifying Dimensions. Dimensions shall be verified against such other drawings or site conditions as pertain to this part of the work.
  2. Existing Services. Any information concerning the location of existing services indicated on this drawing is intended for general guidance only.
  3. Datum. Ordnance Datum Malin (unless noted otherwise).
  4. ESB refers to Electricity Service Board  
 CD refers to Chart Datum  
 OD refers to Ordnance Datum Malin  
 OCR refers to Optical Character Recognition
  5. All white lining arrangements shown indicatively.
  6. Section and elevation details refer to CP1901-3FM-RPS-S45-04-DR-C-0407 to 0413
  7. Proposed Drainage Layout refer to CP1901-3FM-RPS-S45-04-DR-C-0418 to 0421
  8. Proposed Surface Levels refer to CP1901-3FM-RPS-S45-04-DR-C-0424 to 0427
  9. Building Details refer to CP1901-3FM-RPS-S45-04-DR-C-0450 to 0455
  10. Refer to Highways Engineering (HE) Series drawings for External Road Network details.
- Planning Boundary under this application
  - Proposed Scour Protection
  - Proposed new steel tube and sheet pile combi-wall constructed in front of existing caisson quay
  - Existing Great South Wall Exclusion Zone
  - Proposed Refrigerated Units with Plug In Points (Refrs)
  - Proposed High Mast Lighting
  - Proposed ISPS Fencing
  - Container Stacks

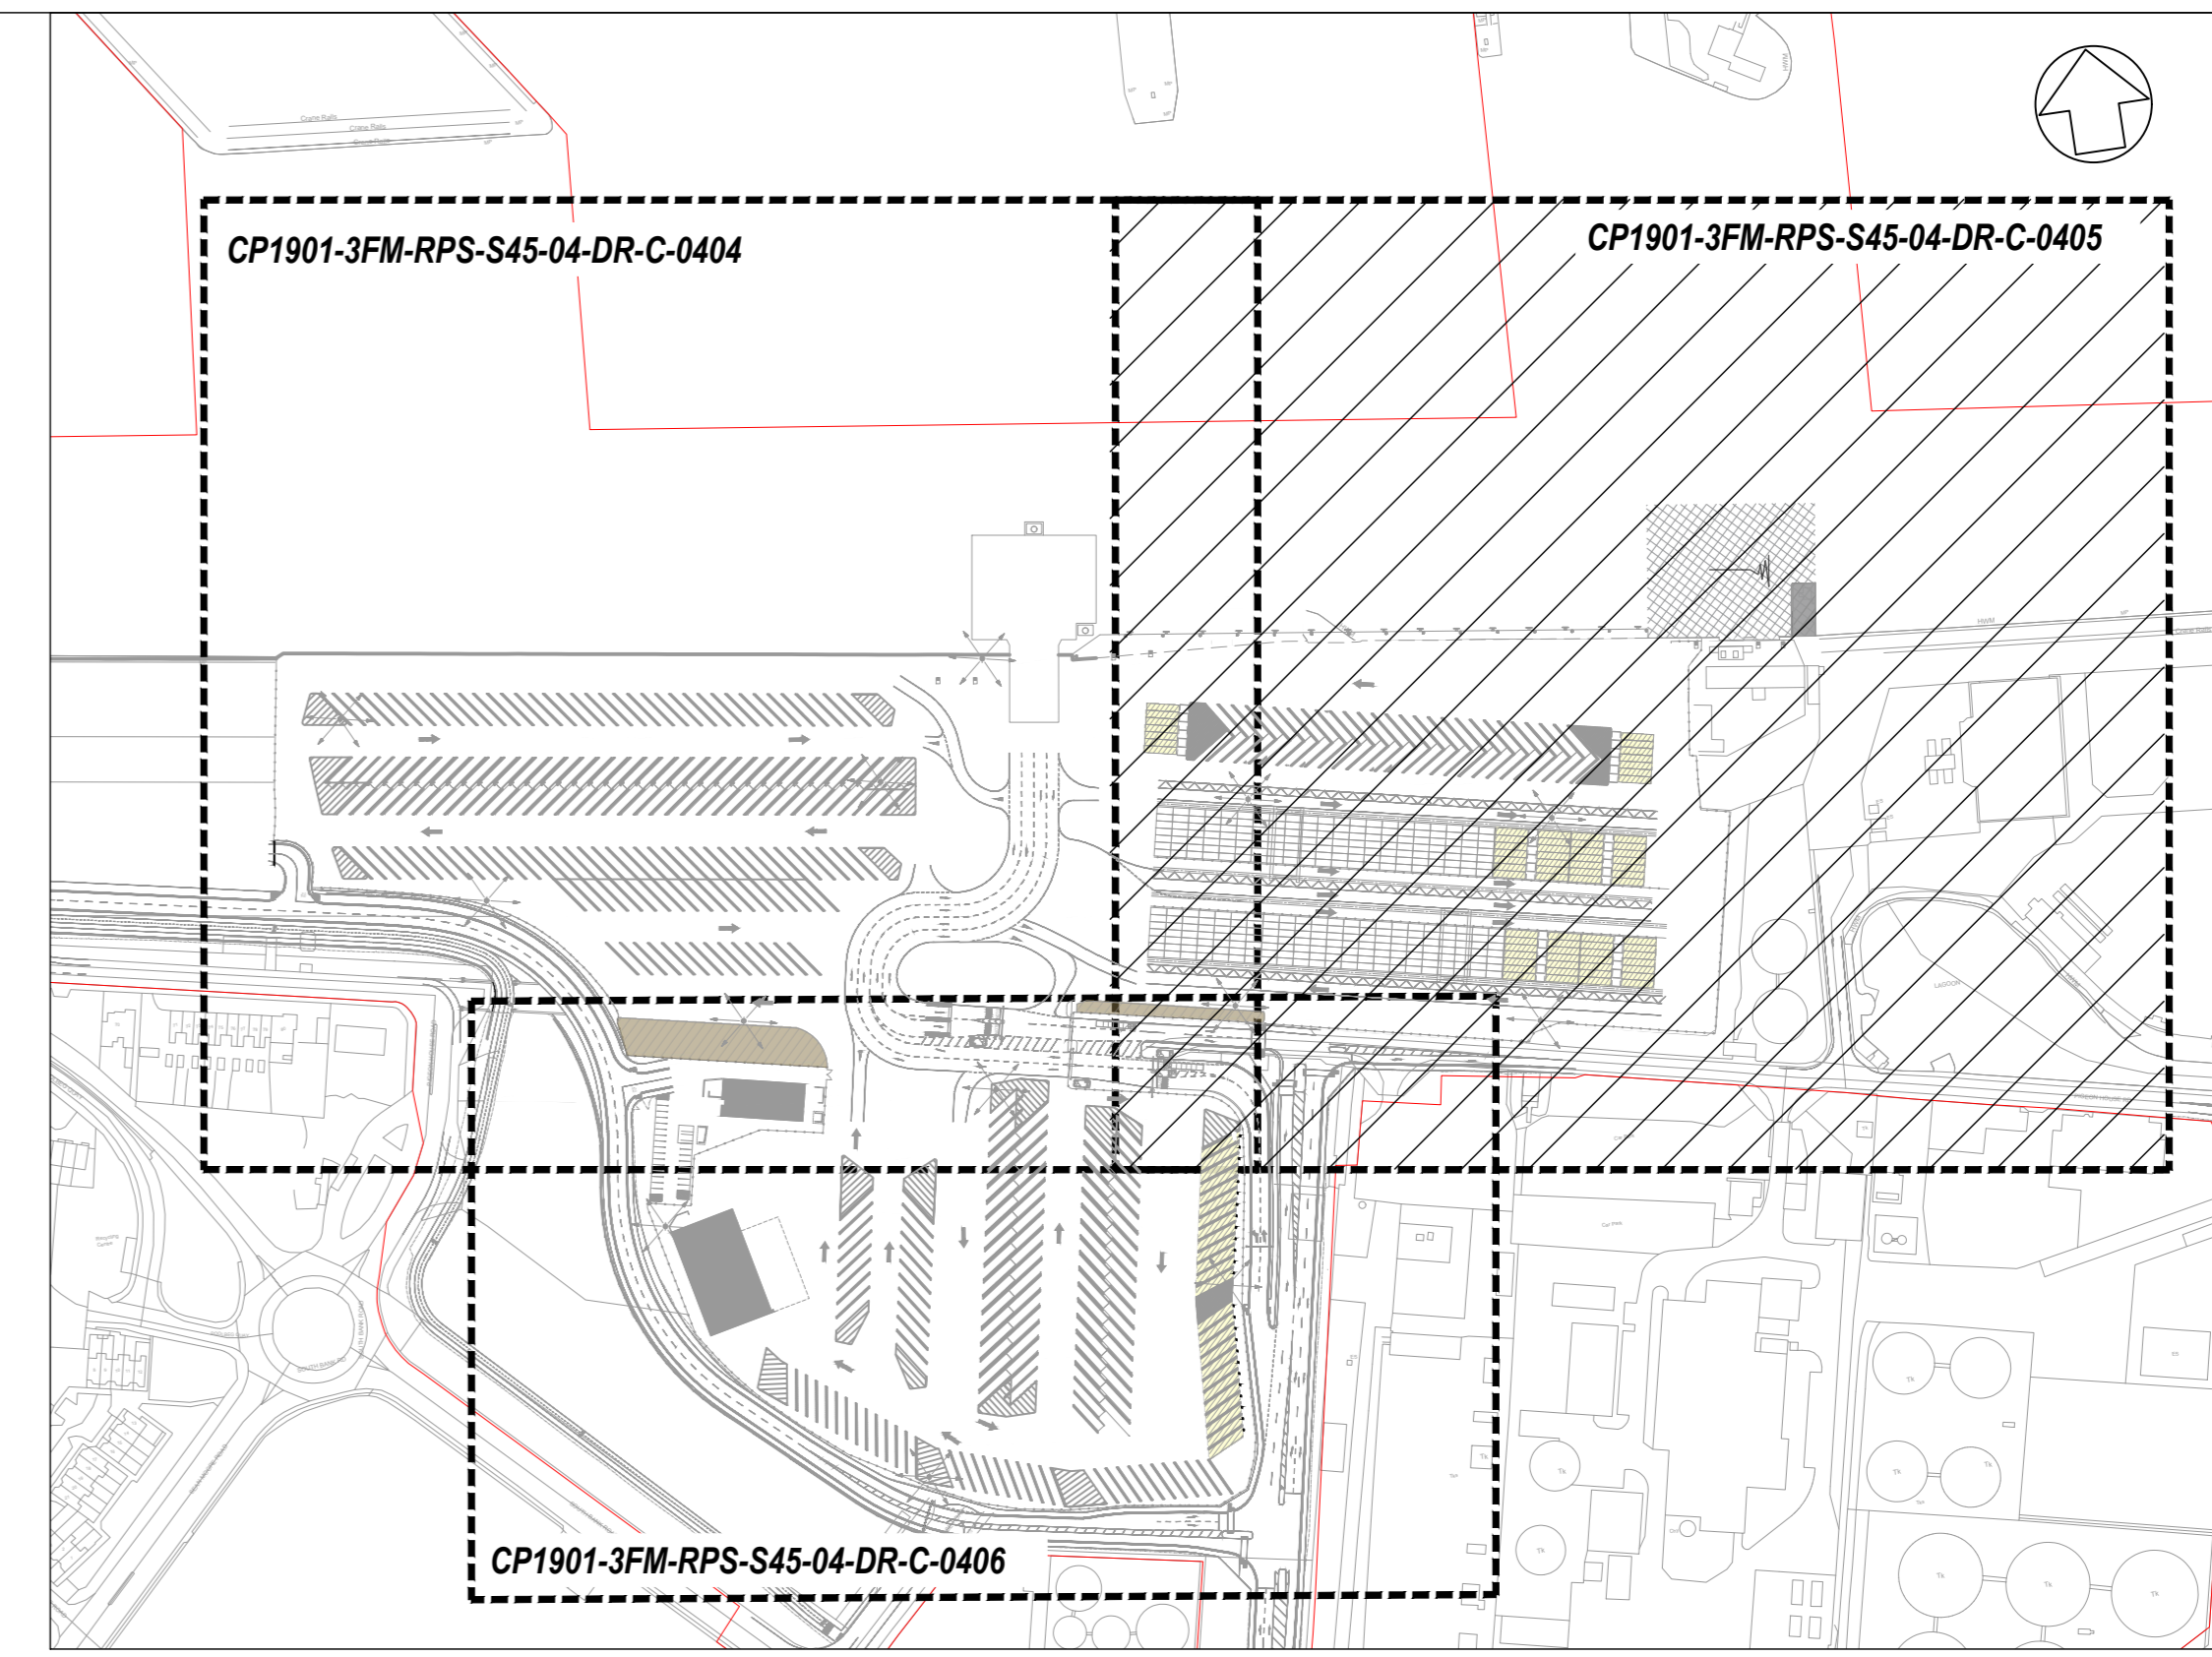

Key Plan showing Viewport Layout [1:3000]

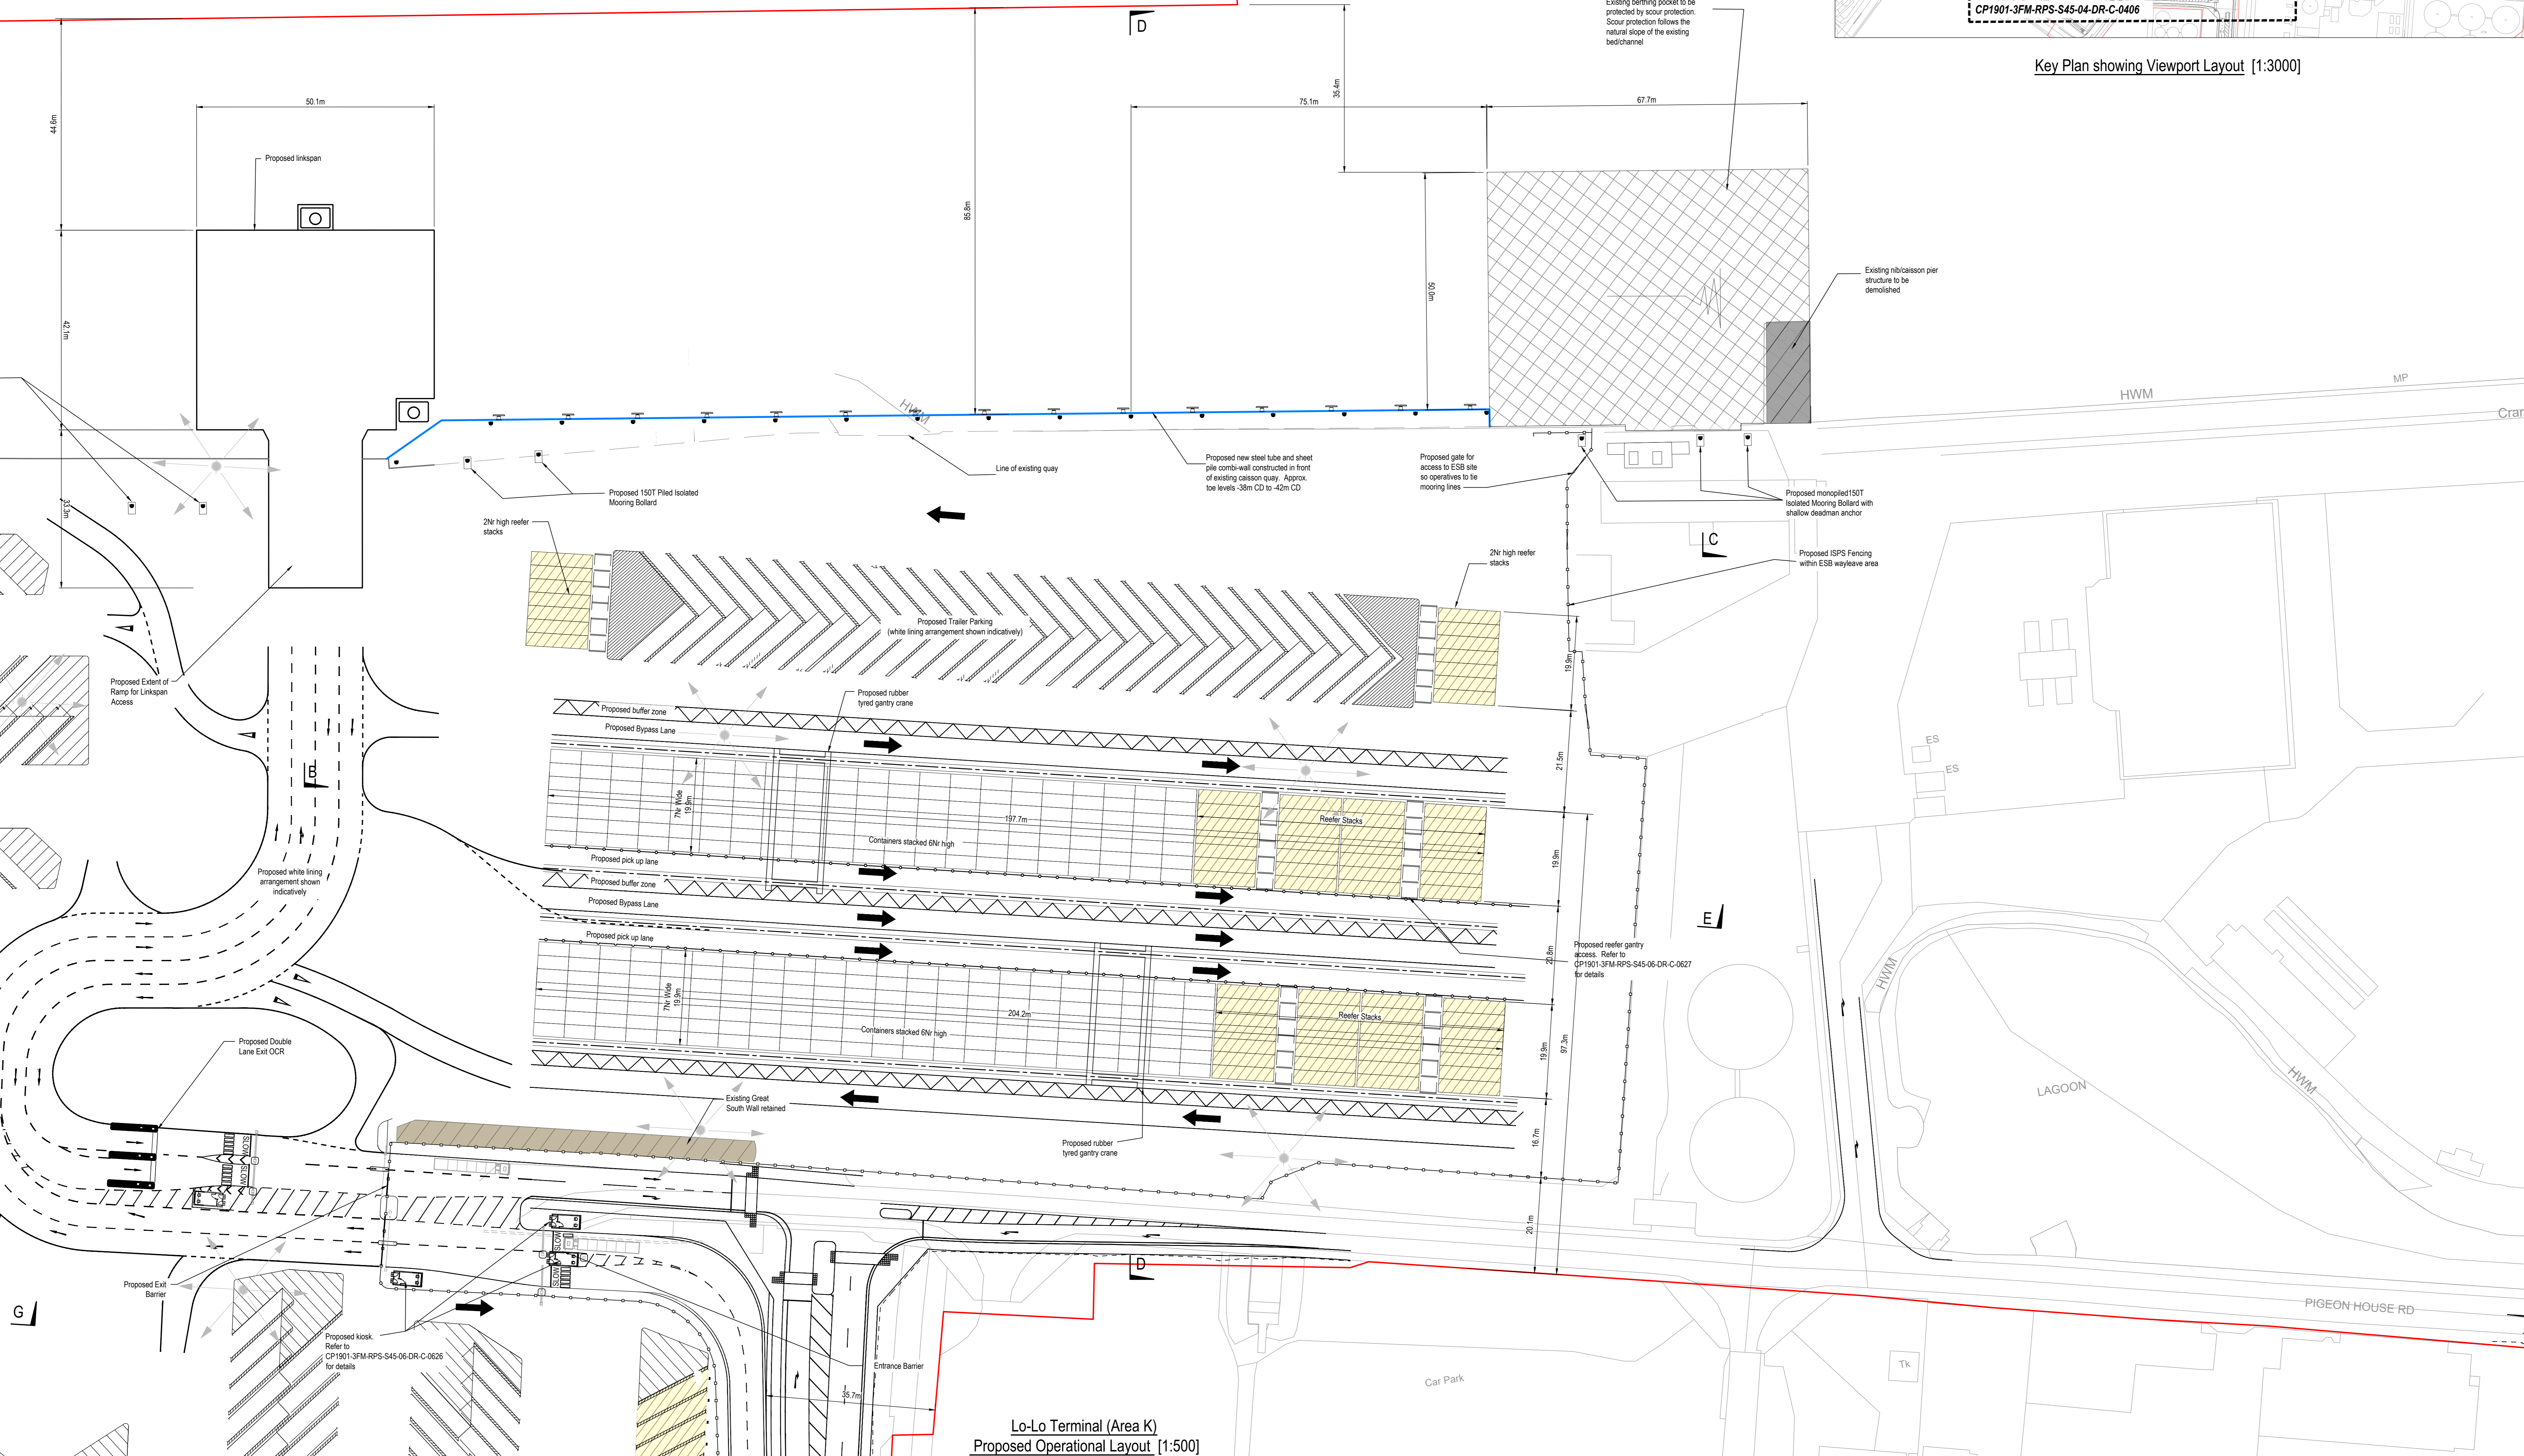

Lo-Lo Terminal (Area K)  
 Proposed Operational Layout [1:500]

PM	Revised for Planning Issues	M.H.	28/06/2024
rev	amendments	check	date
<p>Elmwood House T +44 (0) 28 90 667014        74 Boucher Road F +44 (0) 28 90 666286        Belfast W www.rpsgroup.com/ireland        BT12 6JZ E ireland@rpsgroup.com</p>			
<p>Client  </p>			
<p>Project  </p>			
<p>Title        Ro-Ro Terminal (Area K)        Proposed Operational Layout        Sheet 2</p>			
Project Number	Sheet Size	Drawing Scale	
IBM0842	A0	As Shown	
<p>Drawing Number        CP1901-3FM-RPS-S45-04-DR-C-0405</p>			
Drawn By	Status	Revision	
M.H.	S4	P04	
Checked By	Approved By	Date	
E.H.	M.McC.	20/07/2023	