


- NOTES**
1. Verifying Dimensions. Dimensions shall be verified against such other drawings or site conditions as pertain to this part of the work.
 2. Existing Services. Any information concerning the location of existing services indicated on this drawing is intended for general guidance only.
 3. Datum. Ordnance Datum Malin (unless noted otherwise)
 4. ESB refers to Electricity Service Board. CD refers to Chart Datum. OD refers to Ordnance Datum Malin.
 5. For section locations refer to CP1901-3FM-RPS-S45-04-DR-C-0404 to 0406
 6. Proposed Drainage Layout refer to CP1901-3FM-RPS-S45-04-DR-C-0418 to 0421
 7. Proposed Surfacing Details CP1901-3FM-RPS-S45-04-DR-C-0414 to 0417
 8. Building Details refer to CP1901-3FM-RPS-S45-04-DR-C-0450 to 0455
 9. Refer to Highways Engineering (HE) Series drawings for External Road Network details.
 10. Planning Boundary under this application

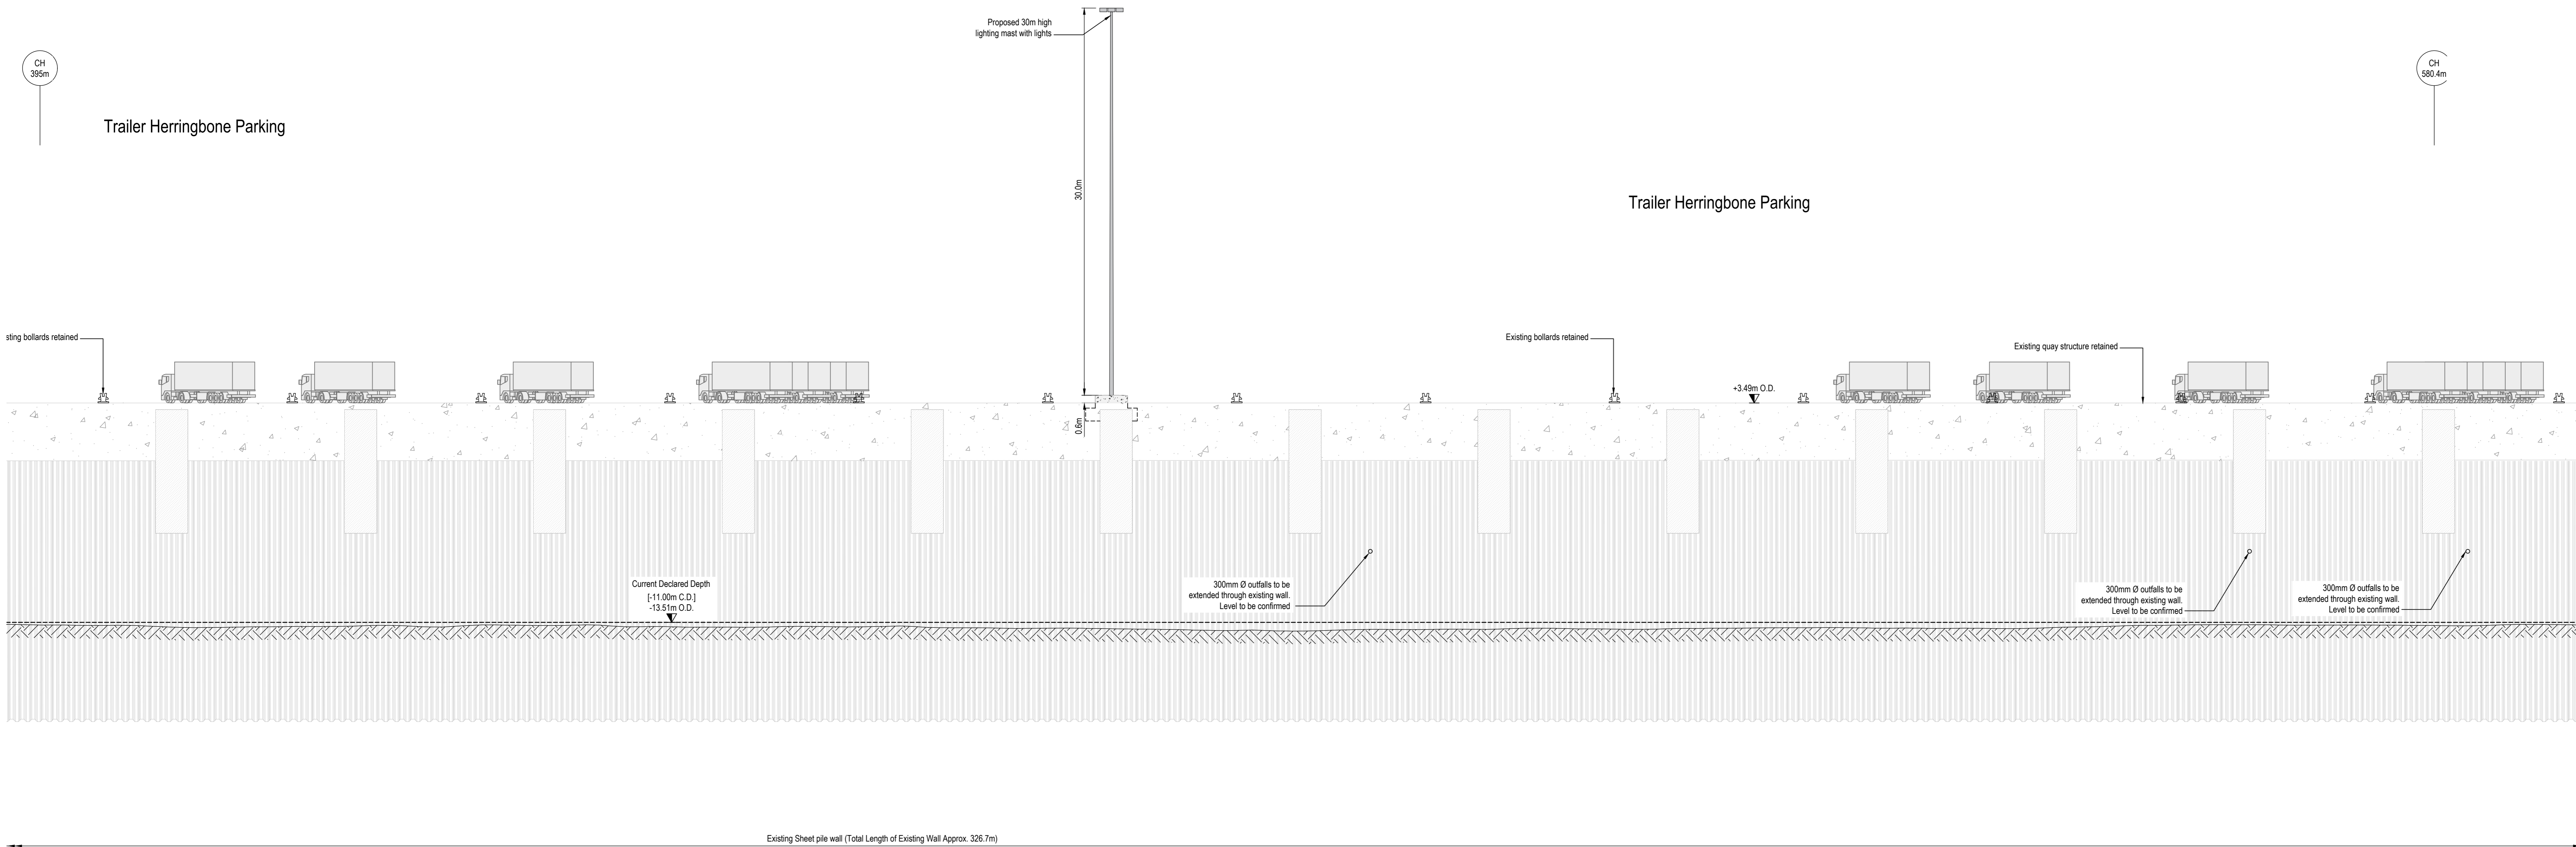


North View looking South
Proposed Elevation on Quay Face
Chainage 395m to 580.4m [1:200]



North View looking South
Proposed Elevation on Quay Face
Chainage 580.4m to 630.7m [1:200]

Key Plan showing Location of Elevation [1:2500]

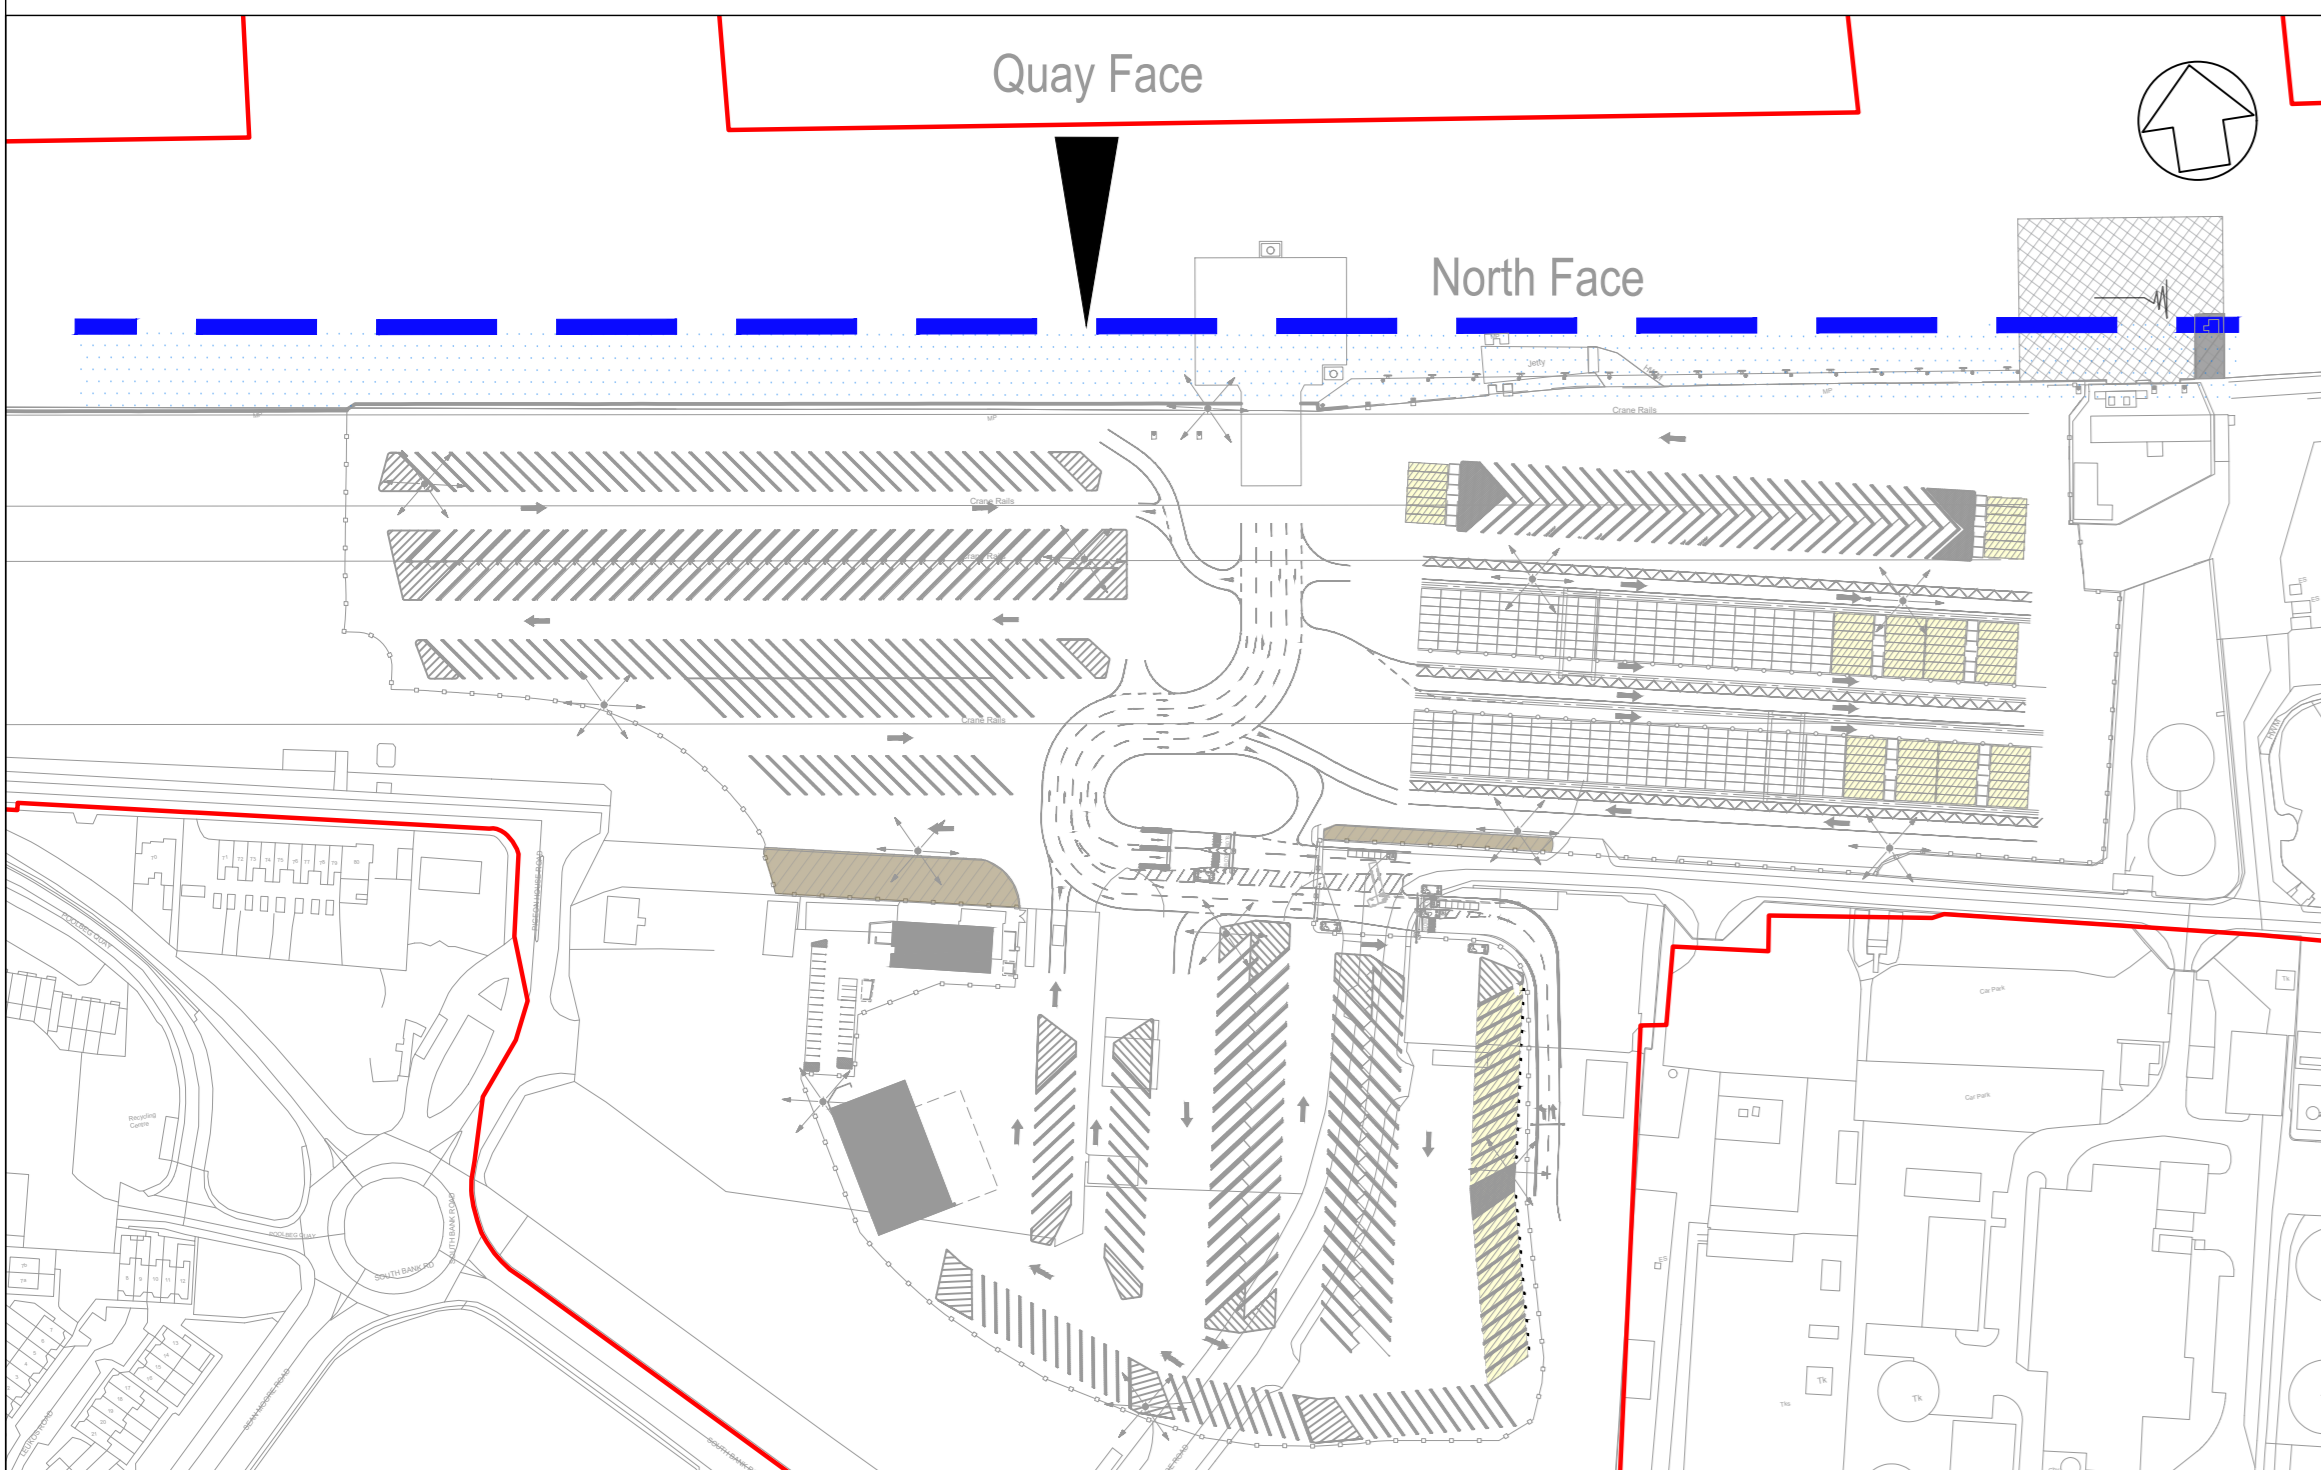

PH1	Revised for Planning Issues	M.H.	28/06/2024
rev	amendments	check	date
<p>Elmwood House T +44 (0) 28 90 667014 74 Booter Road F +44 (0) 28 90 666286 Belfast W www.rpsgroup.com/ireland BT12 6JZ E ireland@rpsgroup.com</p>			
<p>Client</p>			
<p>Project</p>			
<p>Title</p> <p>Ro-Ro Terminal (Area K) Proposed Elevation on Quay Face Sheet 3</p>			
Project Number	Sheet Size	Drawing Scale	
IBM0842	A0	As Shown	
<p>Drawing Number</p> <p>CP1901-3FM-RPS-S45-04-DR-C-0413</p>			
Drawn By	Status	Revision	
M.H.	S4	P01	
Checked By	Approved By	Date	
E.H.	M.M.C.	19/12/2022	