


- NOTES**
1. Verifying Dimensions.
Dimensions shall be verified against such other drawings or site conditions as pertain to this part of the work.
 2. Existing Services.
Any information concerning the location of existing services indicated on this drawing is intended for general guidance only.
 3. Datum. Ordnance Datum Malin (unless noted otherwise)
 4. ESB refers to Electricity Service Board
CD refers to Chart Datum
OD refers to Ordnance Datum Malin
 5. Proposed Drainage Layout refer to
CP1901-3FM-RPS-S45-04-DR-C-0418 to 0421
 6. Proposed Surface Levels
CP1901-3FM-RPS-S45-04-DR-C-0424 to 0427
 7. Refer to Highways Engineering (HE) Series drawings for External Road Network details.
- Area 1
Container Stack Pavement
Type Heavy Duty Pavement
 - Area 2
HGV/Tractor and Trailer Heavy
Duty Pavement
 - Existing Great South Wall. Areas
retained as existing
 - Proposed Reinforced
Concrete Linkspan
 - Proposed Reinforced
Concrete Cope Beam
 - Proposed Buildings. Refer to
CP1901-3FM-RPS-S45-04-DR-C-0450 to 0455 for
details
 - Existing Cope Beam
 - Planning Boundary
under this application

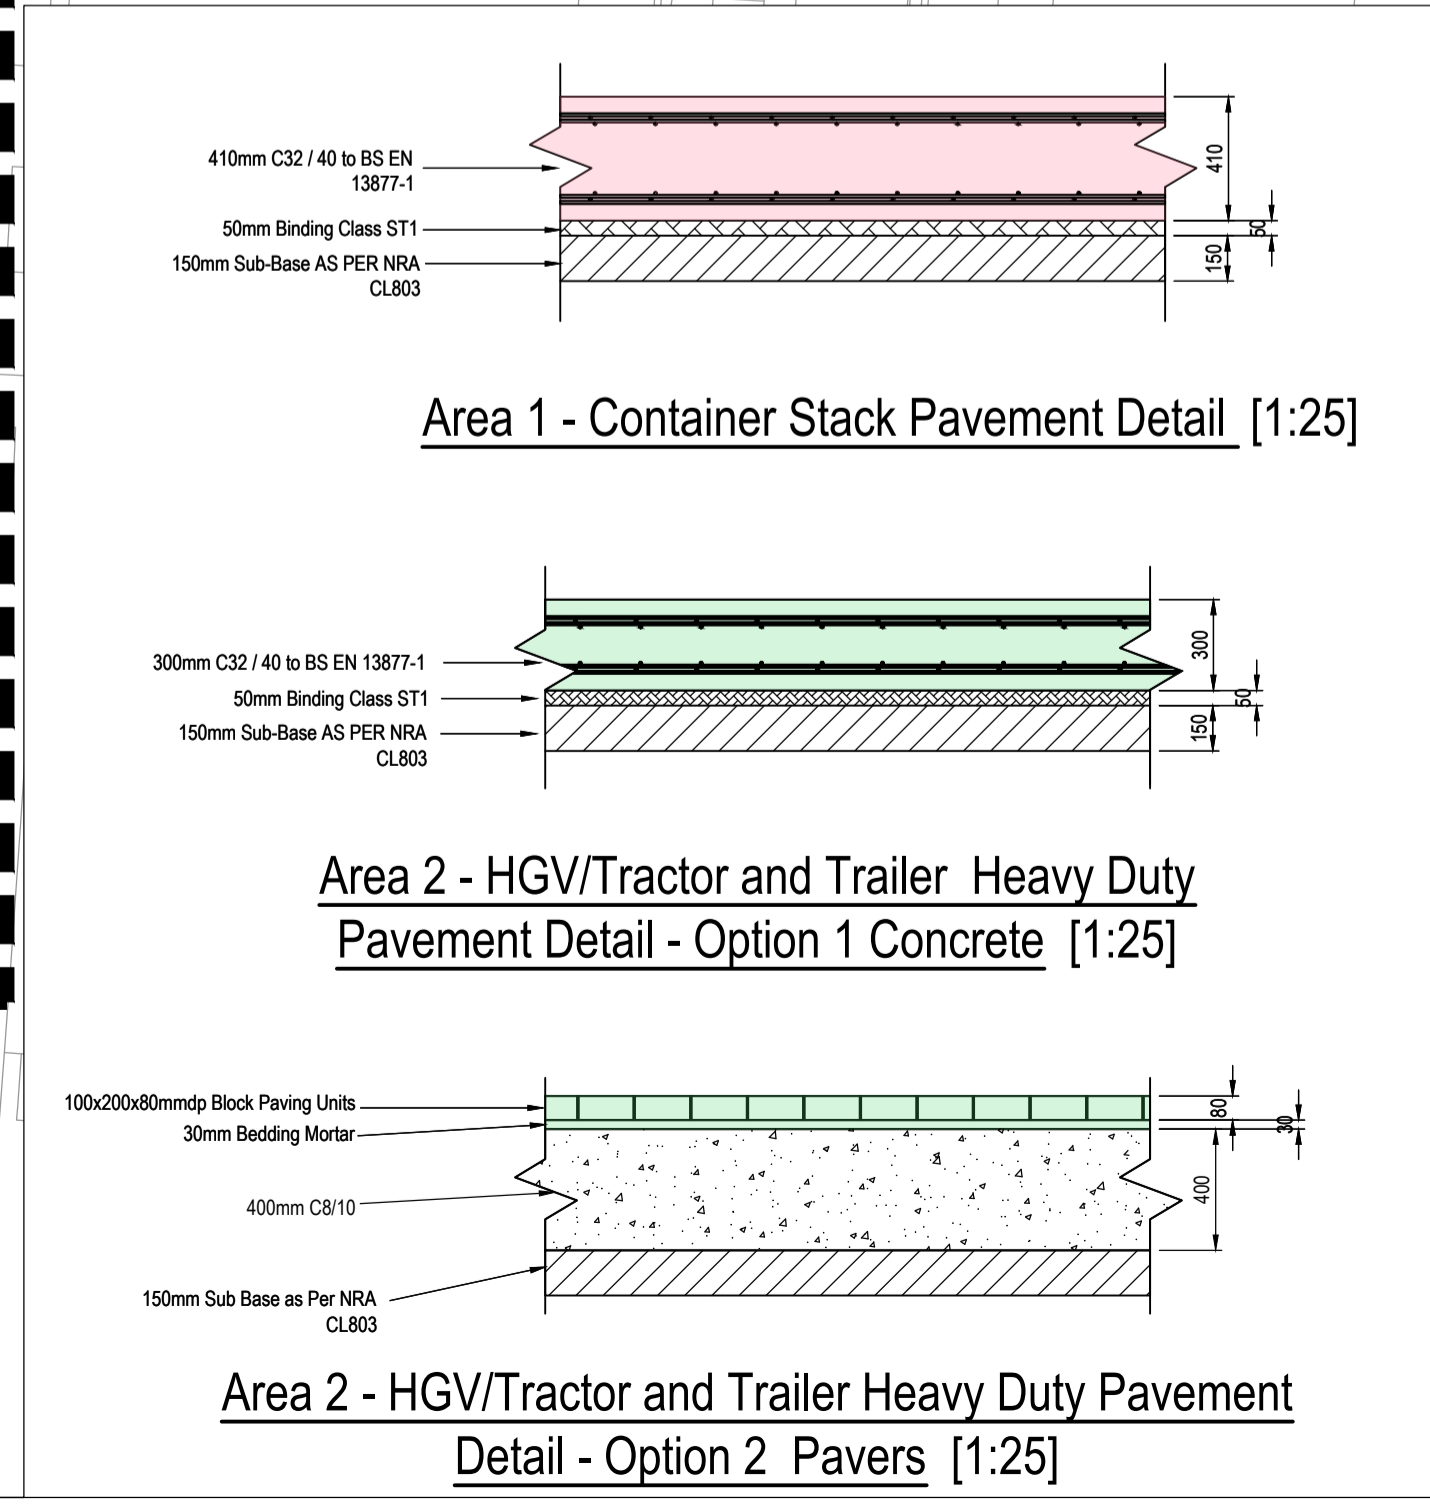

P01	Revised for Planning Issue	M.H.	28/06/2024
rev	amendments	check	date
		Elmwood House 74 Boucher Road Belfast BT12 6RZ T +44 (0) 28 90 667914 F +44 (0) 28 90 668286 W www.rpsgroup.com/ireland E ireland@rpsgroup.com	
Client			
Project			
Title Ro-Ro Terminal (Area K) Proposed Surfacing			
Project Number	Sheet Size	Drawing Scale	
IBM0842	A1	As Shown	
Drawing Number			
CP1901-3FM-RPS-S45-04-DR-C-0414			
Drawn By	Status	Revision	
M.H.	S4	P01	
Checked By	Approved By	Date	
E.H.	M.McC.	19/12/2022	

Ro-Ro Terminal (Area K)
 Proposed Surfacing Layout [1:1250]