



- NOTES**
1. Verifying Dimensions.  
Dimensions shall be verified against such other drawings or site conditions as pertain to this part of the work.
  2. Existing Services.  
Any information concerning the location of existing services indicated on this drawing is intended for general guidance only.
  3. Datum.  
Ordnance Datum Malin (unless noted otherwise)
  4. ESB refers to Electricity Service Board  
CD refers to Chart Datum  
OD refers to Ordnance Datum Malin
  5. Section and elevation details refer to CP1901-3FM-RPS-S45-04-DR-C-0407 to 0413
  6. Proposed Surfacing Layout refer to CP1901-3FM-RPS-S45-04-DR-C-0414 to 0417

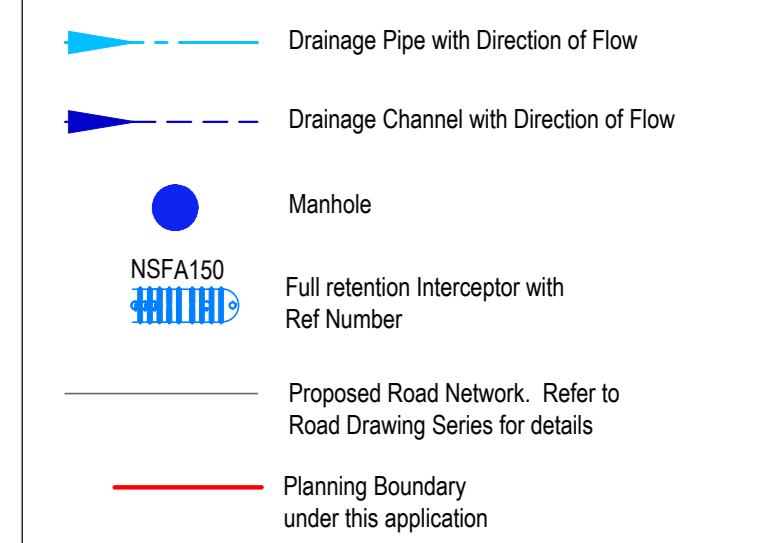

Key Plan showing Viewport Layout [1:3000]

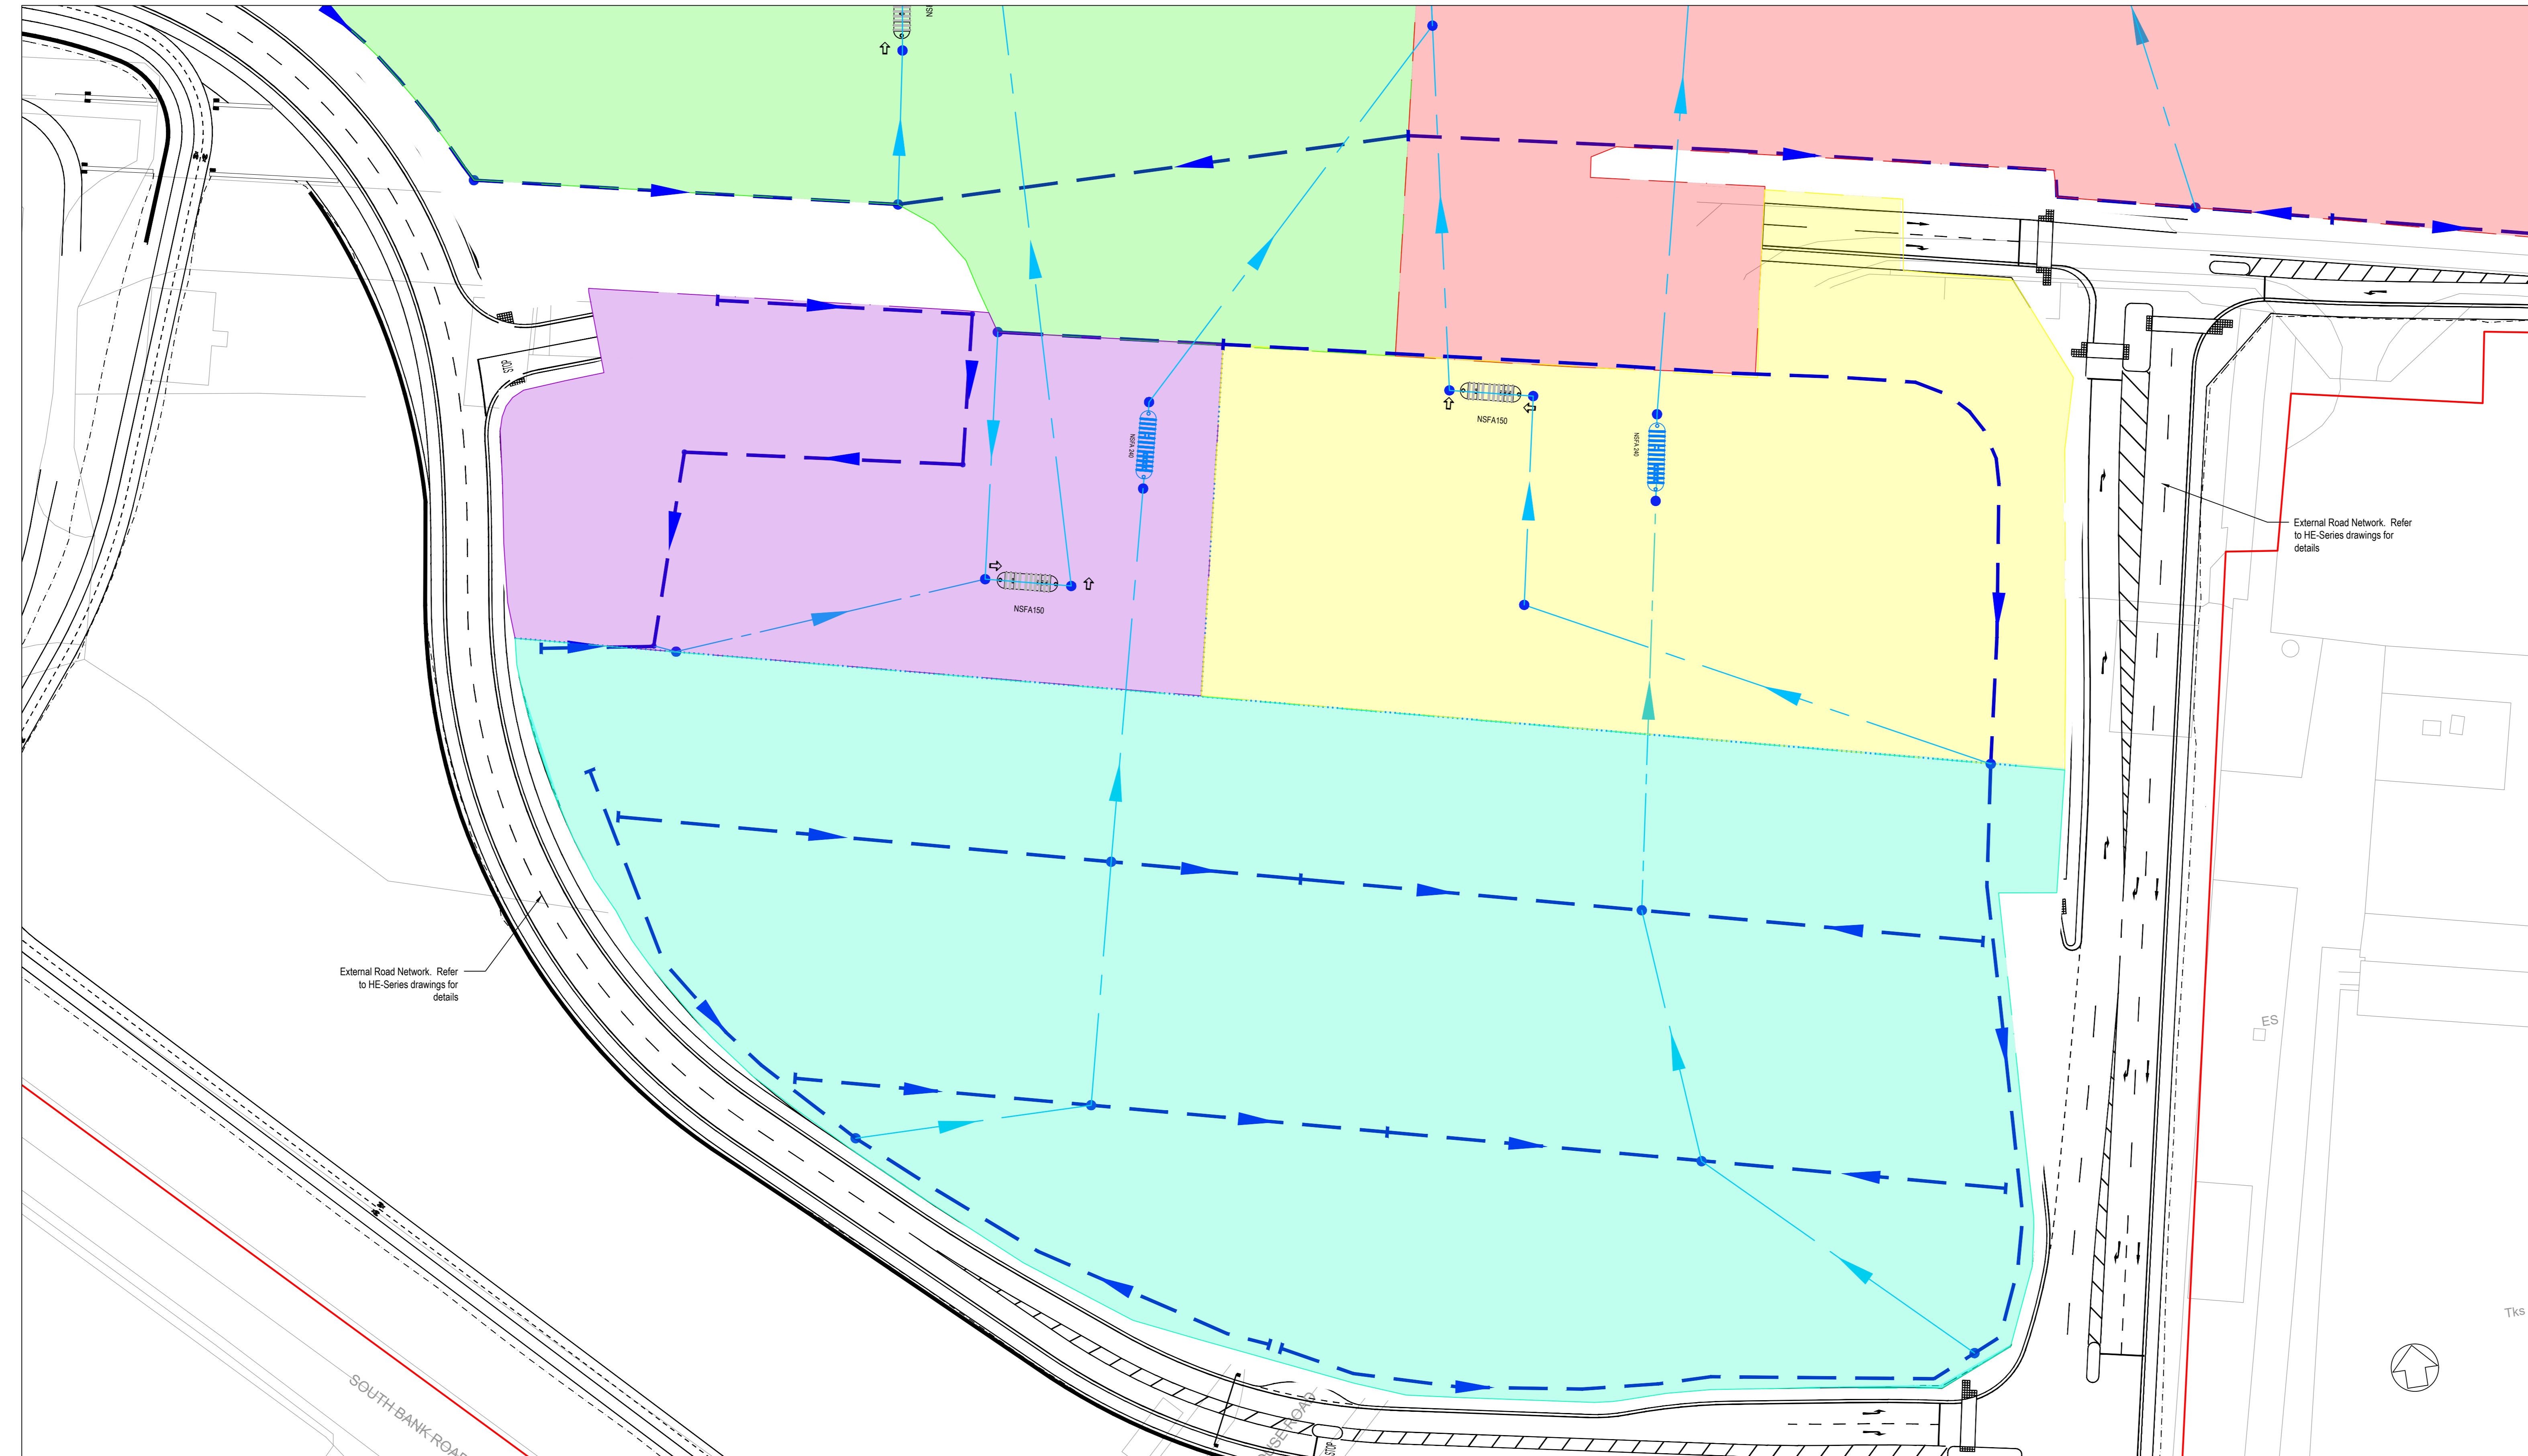

Proposed Drainage Layout [1:500]

|  |                            |               |            |
|--|----------------------------|---------------|------------|
| P01  | Revised for Planning Issue | M.H.          | 28/06/2024 |
| rev  | amendments                 | check         | date       |
|  |                            |               |            |
| <p>Elmwood House T +44 (0) 28 90 667014<br/>       74 Boucher Road F +44 (0) 28 90 665286<br/>       Belfast W www.rpsgroup.com/ireland<br/>       BT12 6SC E ireland@rpsgroup.com</p> |                            |               |            |
| <p>Client</p>  |                            |               |            |
| <p>Project</p>   |                            |               |            |
| <p>Title</p> <p>Ro-Ro Terminal (Area K)<br/>       Proposed Drainage Sheet 3</p>   |                            |               |            |
| Project Number   | Sheet Size                 | Drawing Scale |            |
| IBM0842  | A0                         | As Shown      |            |
| Drawing Number   |                            |               |            |
| CP1901-3FM-RPS-S45-04-DR-C-0421  |                            |               |            |
| Drawn By   | Status                     | Revision      |            |
| M.H.   | S4                         | P01           |            |
| Checked By   | Approved By                | Date          |            |
| E.H.   | M.McC.                     | 19/12/2022    |            |