

- Key:**
- Container / Quay Area Open Piled
  - Oil Access Area
  - Dolphins and Walkways
  - Exclusion Zone for Nesting Terns
  - Oil Fueling Exclusion Zone
  - Great South Wall and ESS Exclusion Zone
  - Great South Wall

- NOTES**
1. Verifying Dimensions. Dimensions shall be verified against such other drawings or site conditions as pertain to this part of the work.
  2. Existing Services. Any information concerning the location of existing services indicated on this drawing is intended for general guidance only.
  3. Datum. Ordnance Datum Mean (unless noted otherwise)
  4. ESS refers to Electricity Service Board  
CD refers to Chart Datum  
OD refers to Ordnance Datum Mean
  5. Section and elevation details refer to CP1901-3FM-RPS-S45-06-DR-C-0607 to 0615
  6. Proposed Drainage Layout refer to CP1901-3FM-RPS-S45-06-DR-C-0616
  7. Proposed Dredge Layout CP1901-3FM-RPS-S45-06-DR-C-0621
  8. Refer to Highways Engineering (HE) Series drawings for Proposed Approach Road details.
- Planning Boundary under this application



Overall Key Map showing Location of Lo-Lo Container Terminal (Area N) [1:25000]

Proposed Berthing Pocket - 800.00m


B

C


Total Length of Berthing Face - 650.00m

126.70m      Approx. 34.22m

Proposed Berthing Pocket Dredge Depth -15.51m O.D. [-13.00m C.D.]

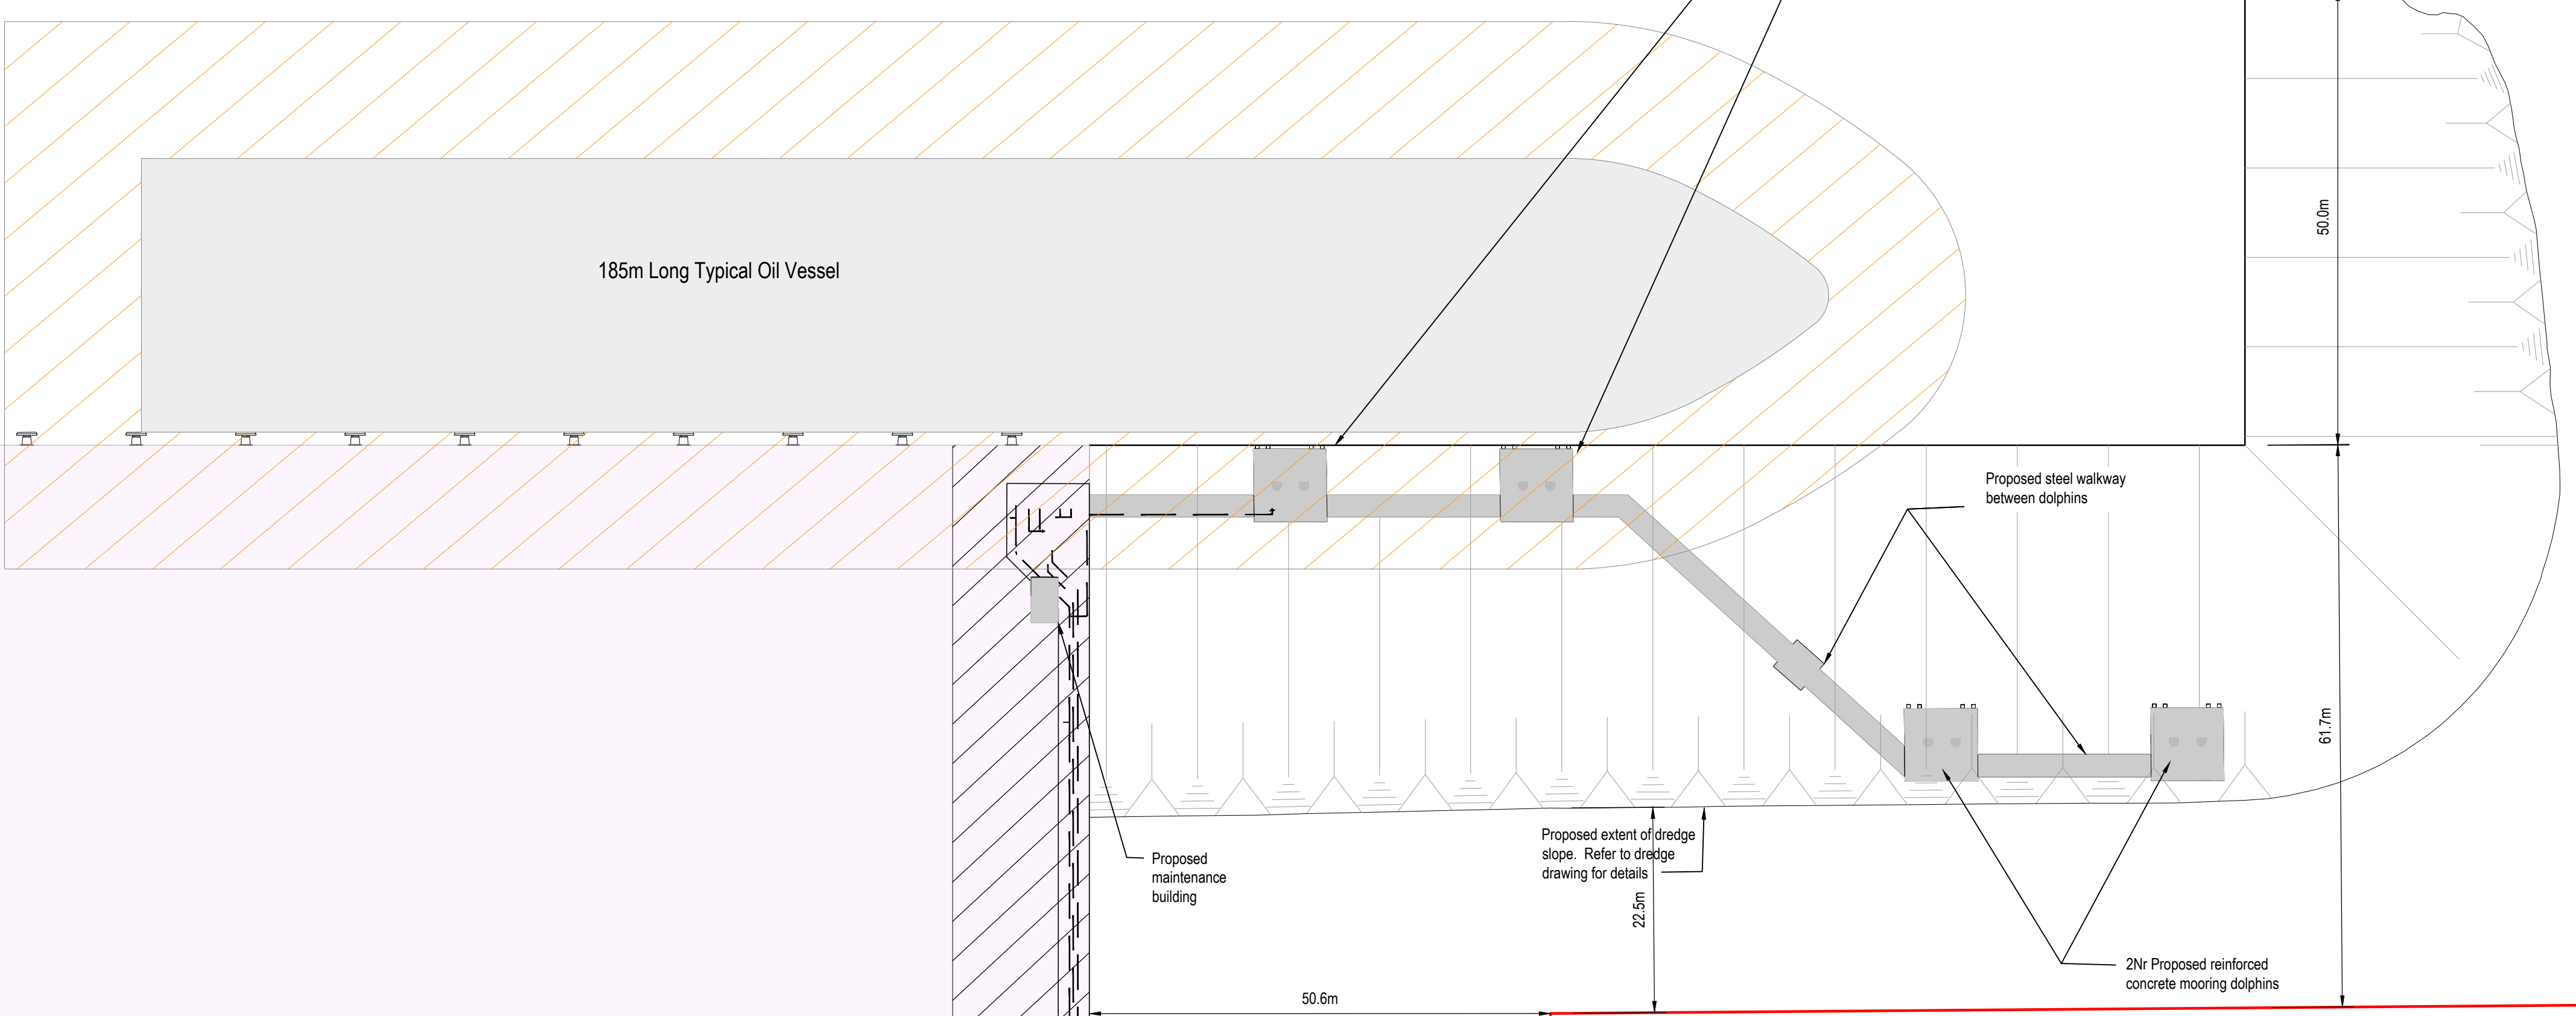

Lo-Lo CONTAINER TERMINAL OPEN PILE DECK STRUCTURE

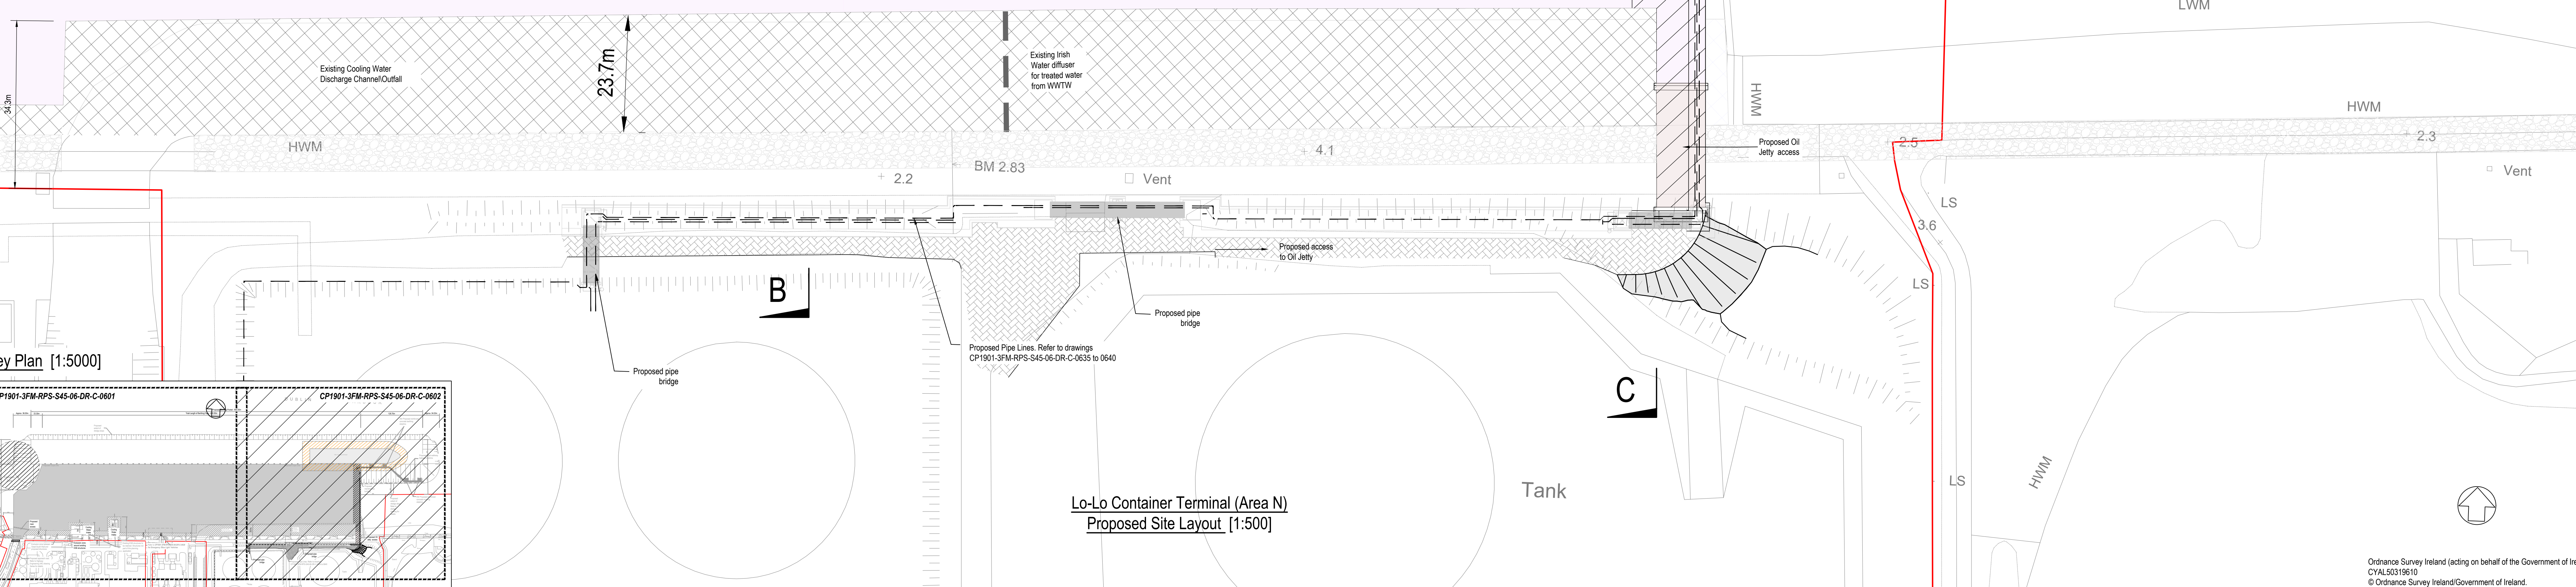

Key Plan [1:5000]

Lo-Lo Container Terminal (Area N) Proposed Site Layout [1:500]

|   |                            |               |            |
|---|----------------------------|---------------|------------|
| PM  | Revised for Planning Issue | M.H.          | 28/06/2024 |
| rev   | amendments                 | check         | date       |
|   |                            |               |            |
| <p>Client: <b>COMHACHT CHALAFORT ATHA CLIATH DUBLIN PORT COMPANY</b></p>            |                            |               |            |
| <p>Project: <b>3FMProject</b></p>   |                            |               |            |
| <p>Title: <b>Lo-Lo Container Terminal (Area N) Proposed Site Layout Sheet 2</b></p> |                            |               |            |
| Project Number  | Sheet Size                 | Drawing Scale |            |
| IBM0842   | A0                         | As Shown      |            |
| <p>Drawing Number: <b>CP1901-3FM-RPS-S45-06-DR-C-0603</b></p>                       |                            |               |            |
| Drawn By  | Status                     | Revision      |            |
| M.H.  | S4                         | P04           |            |
| Checked By  | Approved By                | Date          |            |
| K.A.G.  | M.M.C.                     | 20/07/2023    |            |

Ordnance Survey Ireland (acting on behalf of the Government of Ireland)  
CYAL53319610  
© Ordnance Survey Ireland/Government of Ireland.