


Ordnance Survey Ireland (acting on behalf of the Government of Ireland):
CYAL50319610
© Ordnance Survey Ireland/Government of Ireland.

Key Plan showing Location of Elevation [1:2500]

NOTES

1. Verifying Dimensions.
Dimensions shall be verified against such other drawings or site conditions as pertain to this part of the work.
2. Existing Services.
Any information concerning the location of existing services indicated on this drawing is intended for general guidance only.
3. Datum.
Ordnance Datum Malin (unless noted otherwise)
4. Cope refers to Quay Berthing Face
ESB refers to Electricity Service Board
CD refers to Chart Datum
OD refers to Ordnance Datum Malin
M.H.W.S. Mean High Water Springs
M.L.W.S. Mean Low Water Springs
5. Refer to drawing CP1901-3FM-RPS-S45-06-DR-C-0601 to 0606 for section locations.
6. Section and elevation details refer to CP1901-3FM-RPS-S45-06-DR-C-0607 to 0615
7. Proposed Drainage Layout refer to CP1901-3FM-RPS-S45-06-DR-C-0616 to 0618
8. Refer to Highways Engineering (HE) Series drawings for Proposed Approach Road details.

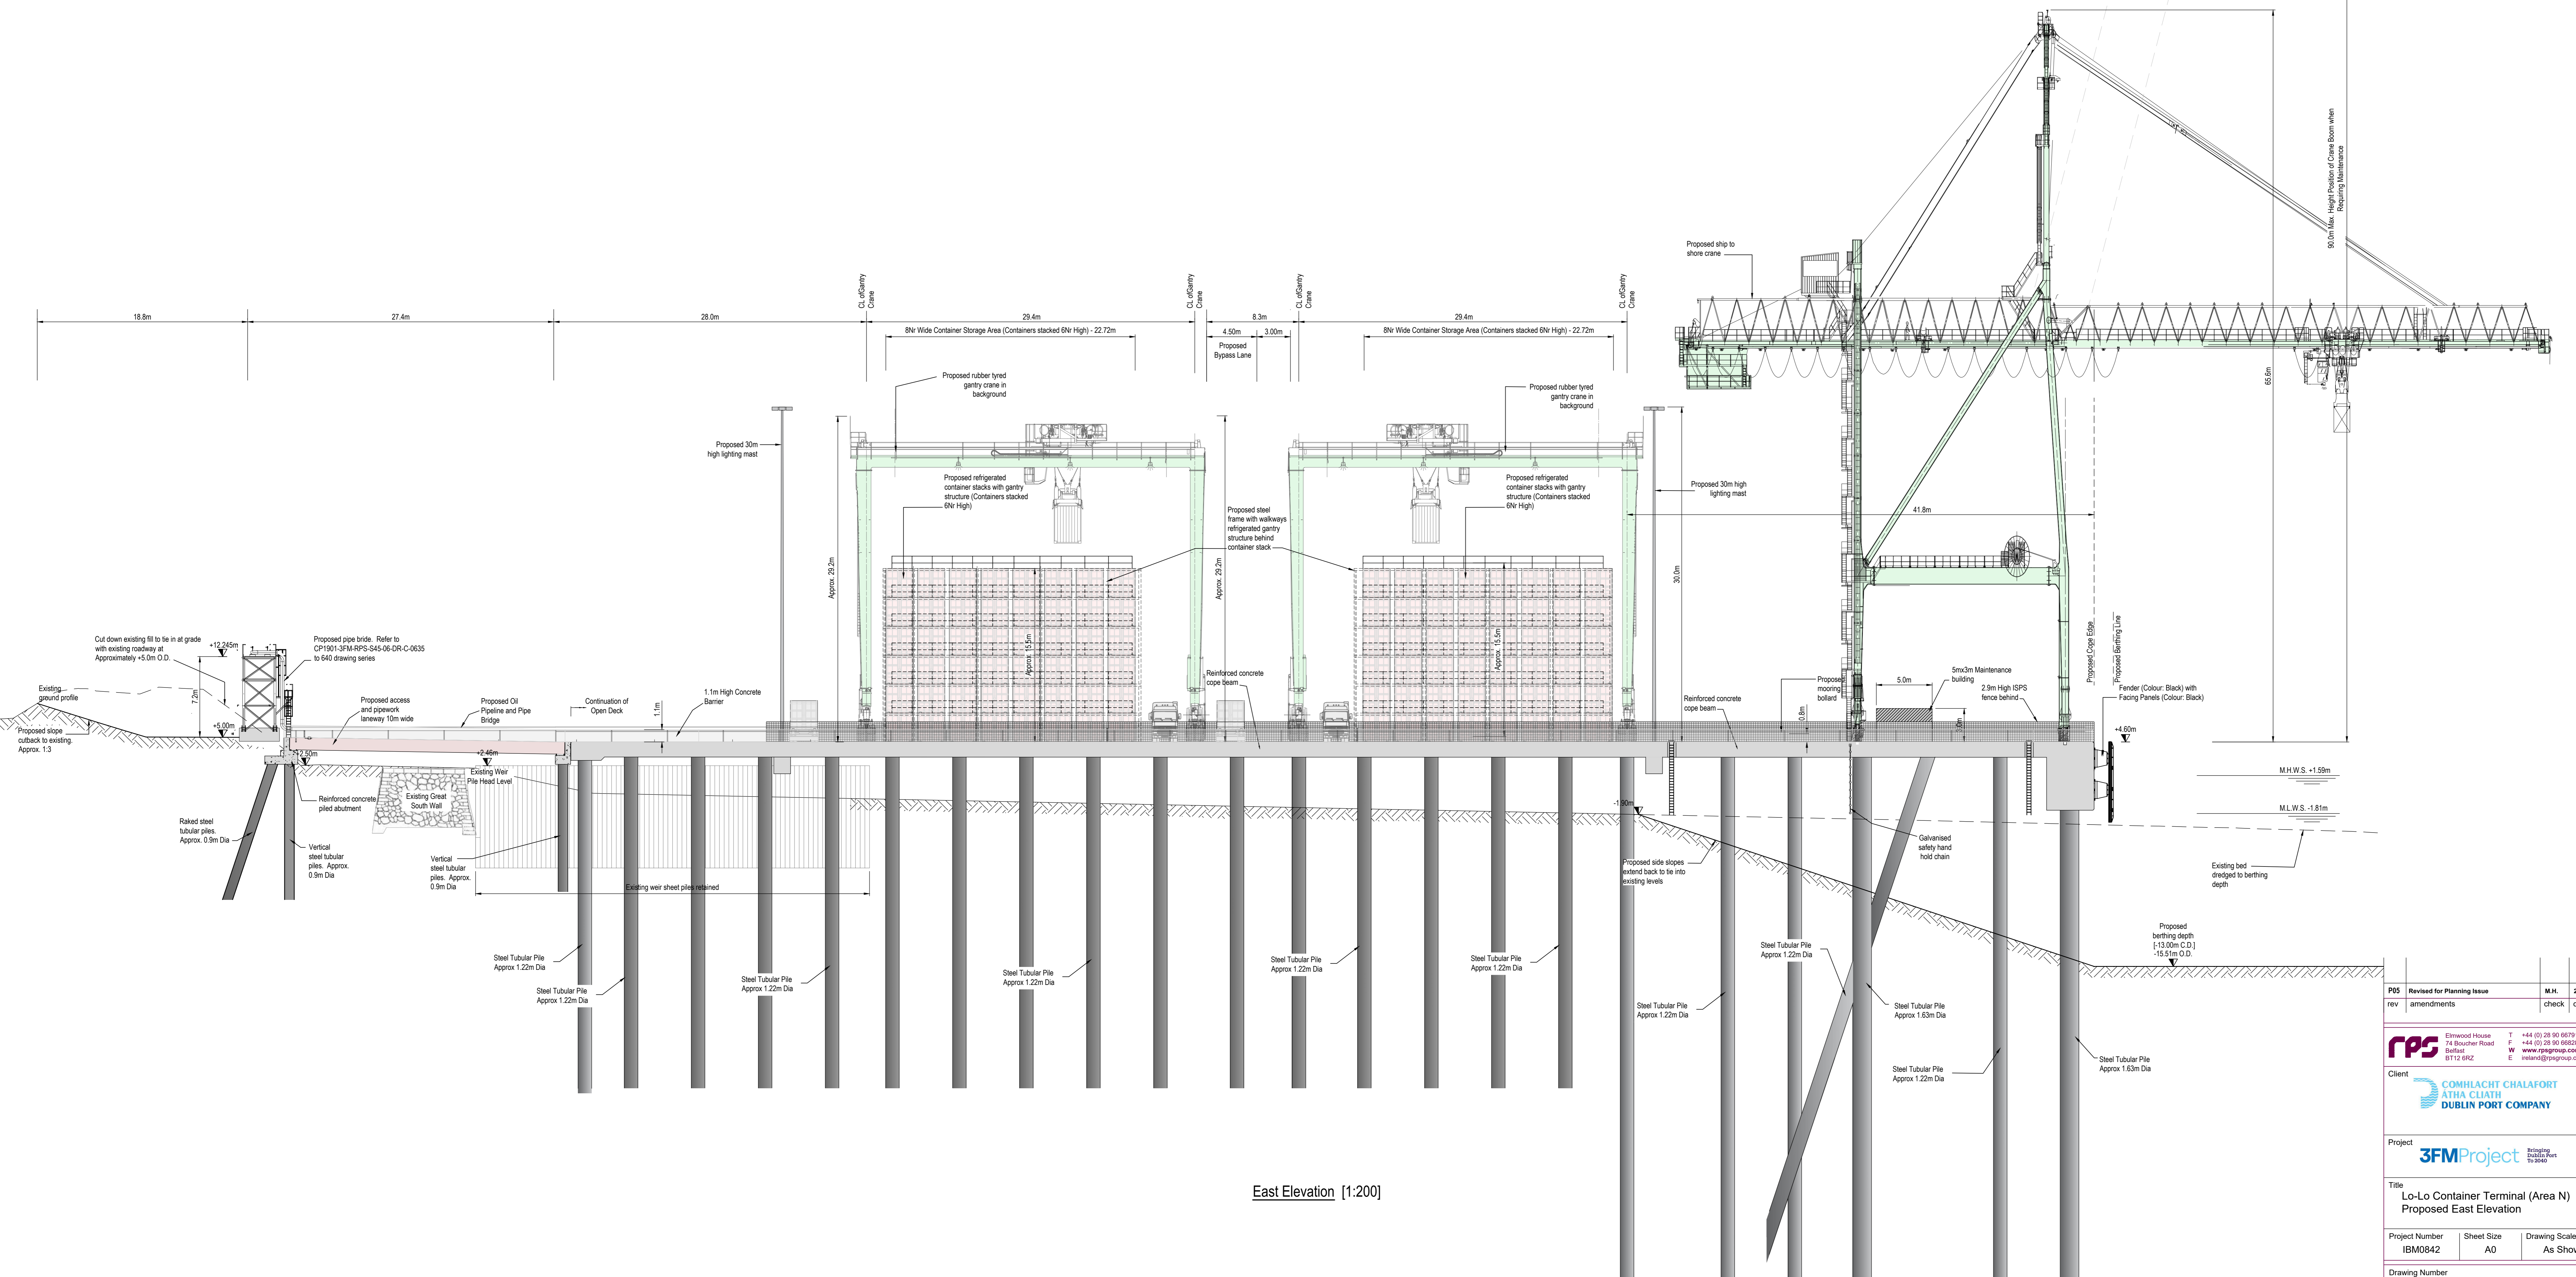

East Elevation [1:200]

P05	Revised for Planning Issue	M.H.	28/06/2024
rev	amendments	check	date
<p>Client: COMHLACHT CHALAFORT ATHA CLATH DUBLIN PORT COMPANY</p>			
<p>Project: 3FMProject</p>			
<p>Title: Lo-Lo Container Terminal (Area N) Proposed East Elevation</p>			
Project Number	Sheet Size	Drawing Scale	
IBM0842	A0	As Shown	
Drawing Number: CP1901-3FM-RPS-S45-06-DR-C-0614			
Drawn By	Status	Revision	
M.H.	S4	P05	
Checked By	Approved By	Date	
K.A.G.	M.McC.	20/07/2023	