



Key Plan Showing Section A-A and B-B
Location [1:2000]

- NOTES**
1. Verifying Dimensions. Dimensions shall be verified against such other drawings or site conditions as pertain to this part of the work.
 2. Existing Services. Any information concerning the location of existing services indicated on this drawing is intended for general guidance only.
 3. Datum. Ordnance Datum Malin (unless noted otherwise)
 4. For Surface Make up refer to CP1901-3FM-RPS-S45-06-DR-C-0743
 5. For Drainage Layout refer to CP1901-3FM-RPS-S45-06-DR-C-0744
 6. For Proposed Levels refer to CP1901-3FM-RPS-S45-06-DR-C-0740
- ▽ +4.73m Existing Level
▽ +4.42m Proposed Level
— Planning Boundary under this application

Ordnance Survey Ireland (acting on behalf of the Government of Ireland);
 CYAL50319610
 © Ordnance Survey Ireland/Government of Ireland.

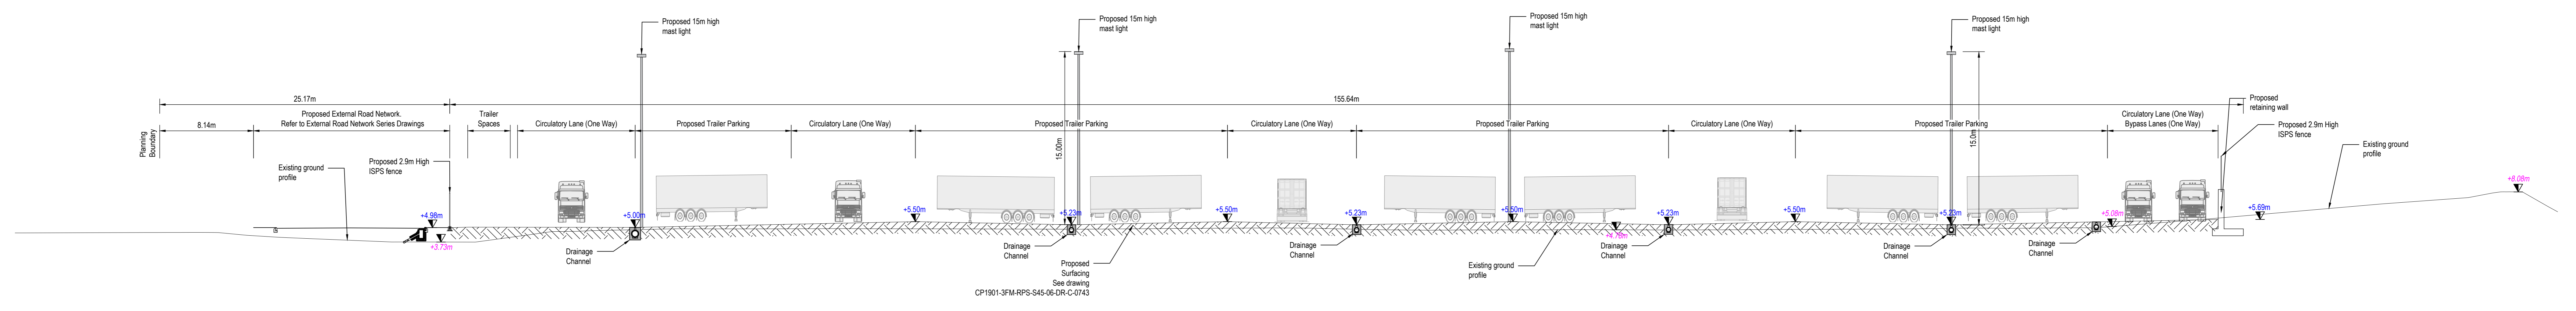

Ro-Ro Terminal Yard (Area O):
Section A-A [1:200]

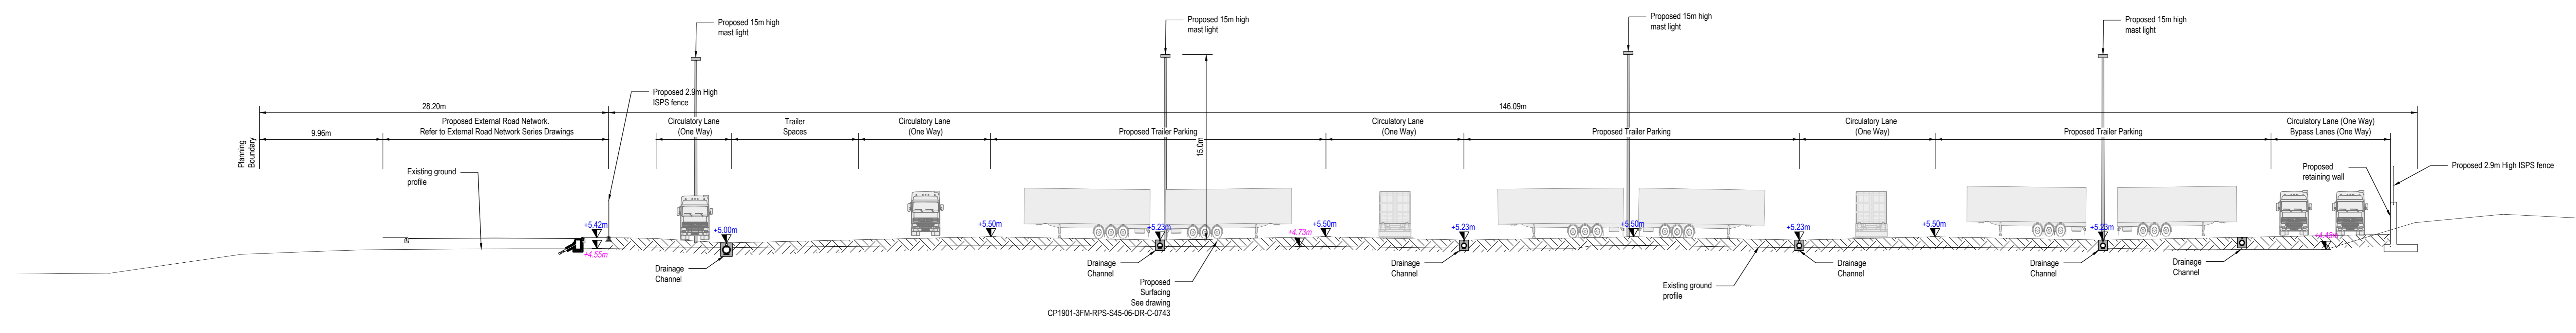

Ro-Ro Terminal Yard (Area O):
Section B-B [1:200]

P03	Revised for Planning Issue	M.H.	28/06/2024
rev	amendments	check	date
<p>rps Elmwood House T +44 (0) 28 30 667014 74 Boucher Road F +44 (0) 28 30 665286 Belfast W www.rpsgroup.com/ireland BT1 1L 6E2 E ireland@rpsgroup.com</p>			
<p>Client COMHLACHT CHALAFORT ATHA CIATH DUBLIN PORT COMPANY</p>			
<p>Project 3FMProject</p>			
<p>Title Ro-Ro Terminal Yard (Area O) Proposed Cross Section A-A and B-B</p>			
Project Number	Sheet Size	Drawing Scale	
IBM0842	A0	As Shown	
<p>Drawing Number CP1901-3FM-RPS-S45-07-DR-C-0702</p>			
Drawn By	Status	Revision	
M.H.	S4	P03	
Checked By	Approved By	Date	
B.M.	M.McC.	26/02/2024	