



- NOTES**
1. Verifying Dimensions. Dimensions shall be verified against such other drawings or site conditions as pertain to this part of the work.
 2. Existing Services. Any information concerning the location of existing services indicated on this drawing is intended for general guidance only.
 3. Datum. Ordnance Datum Malin (unless noted otherwise)
 4. For Surface Make up refer to CP1901-3FM-RPS-S45-06-DR-C-0743
 5. For Drainage Layout refer to CP1901-3FM-RPS-S45-06-DR-C-0744
 6. For Proposed Levels refer to CP1901-3FM-RPS-S45-06-DR-C-0740
- +4.42m Existing Level
 +4.42m Proposed Level
 Planning Boundary under this application

Key Plan Showing Section Location [1:2000]
 Ordnance Survey Ireland (acting on behalf of the Government of Ireland): CYAL503196/10 © Ordnance Survey Ireland/Government of Ireland.

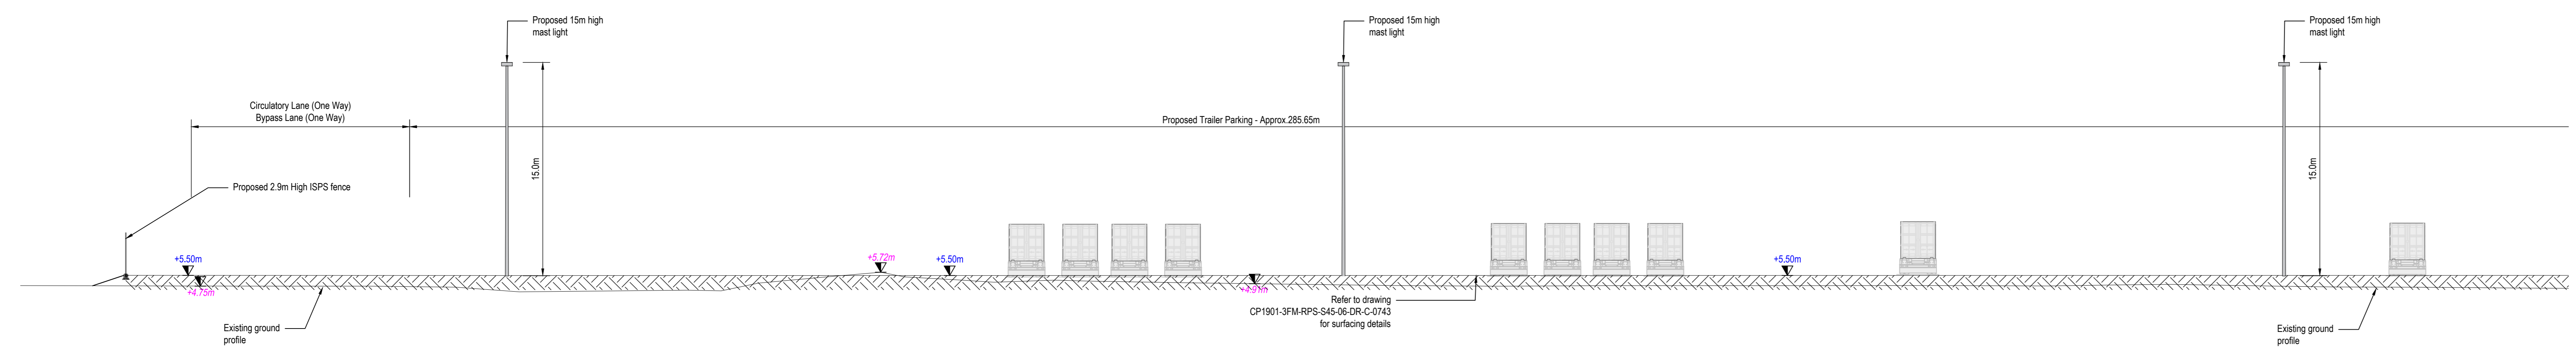

Ro-Ro Terminal Yard (Area O) : Section C-C: Part 01 [1:200]

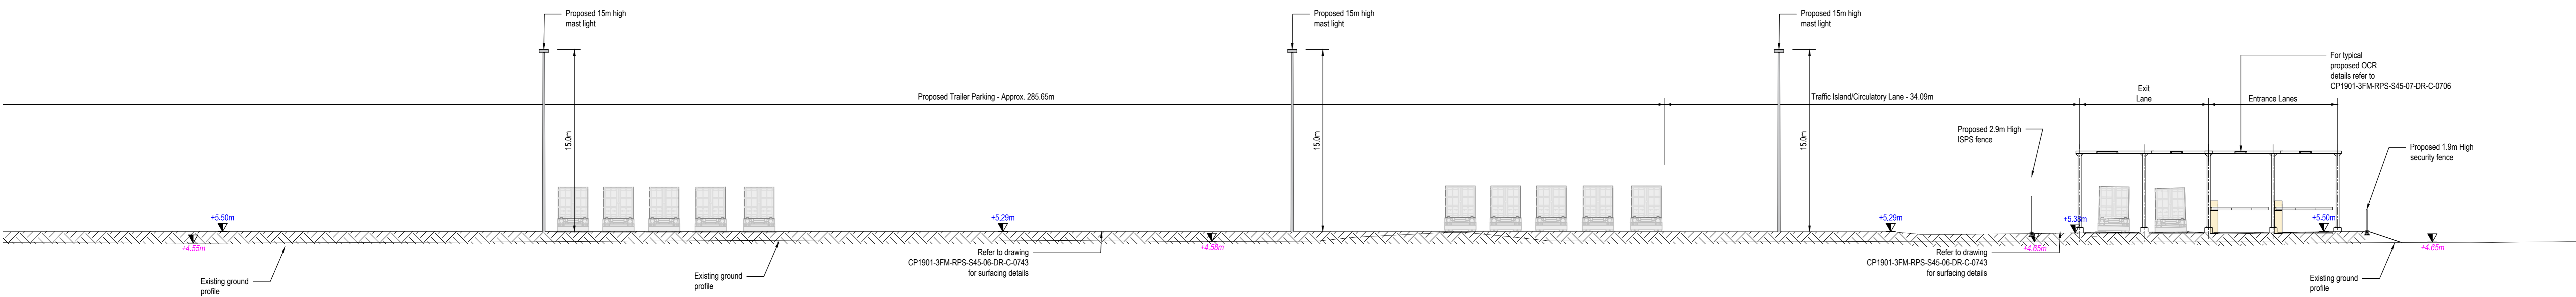

Ro-Ro Terminal Yard (Area O) : Section C-C: Part 02 [1:200]

PO3	Revised for Planning Issue	M.M.	26/02/2024
rev	amendments	check	date
		Elmwood House T +44 (0) 28 90 667014 74 Boucher Road F +44 (0) 28 90 666286 Belfast B1 1L 6E2 W www.rpsgroup.com/ireland E ireland@rpsgroup.com	
Client			
Project			
Title			
Ro-Ro Terminal Yard (Area O) Proposed Cross Section C-C			
Project Number	Sheet Size	Drawing Scale	
IBM0842	A0	As Shown	
Drawing Number			
CP1901-3FM-RPS-S45-07-DR-C-0703			
Drawn By	Status	Revision	
M.H.	S4	P03	
Checked By	Approved By	Date	
B.M.	M.McC.	26/02/2024	