



Ordnance Survey Ireland (acting on behalf of the Government of Ireland)
 CYAL50319810
 © Ordnance Survey Ireland/Government of Ireland. **East and West Elevation: Key Plan showing Elevation Location [1:2000]**

- NOTES**
1. Verifying Dimensions. Dimensions shall be verified against such other drawings or site conditions as pertain to this part of the work.
 2. Existing Services. Any information concerning the location of existing services indicated on this drawing is intended for general guidance only.
 3. Datum. Ordnance Datum Malin (unless noted otherwise)
 4. For Surface Make up refer to CP1901-3FM-RPS-S45-06-DR-C-0743
 5. For Drainage Layout refer to CP1901-3FM-RPS-S45-06-DR-C-0744
 6. For Proposed Levels refer to CP1901-3FM-RPS-S45-06-DR-C-0740
- ▽ +4.75m Existing Level
▽ +4.42m Proposed Level
— Planning Boundary under this application

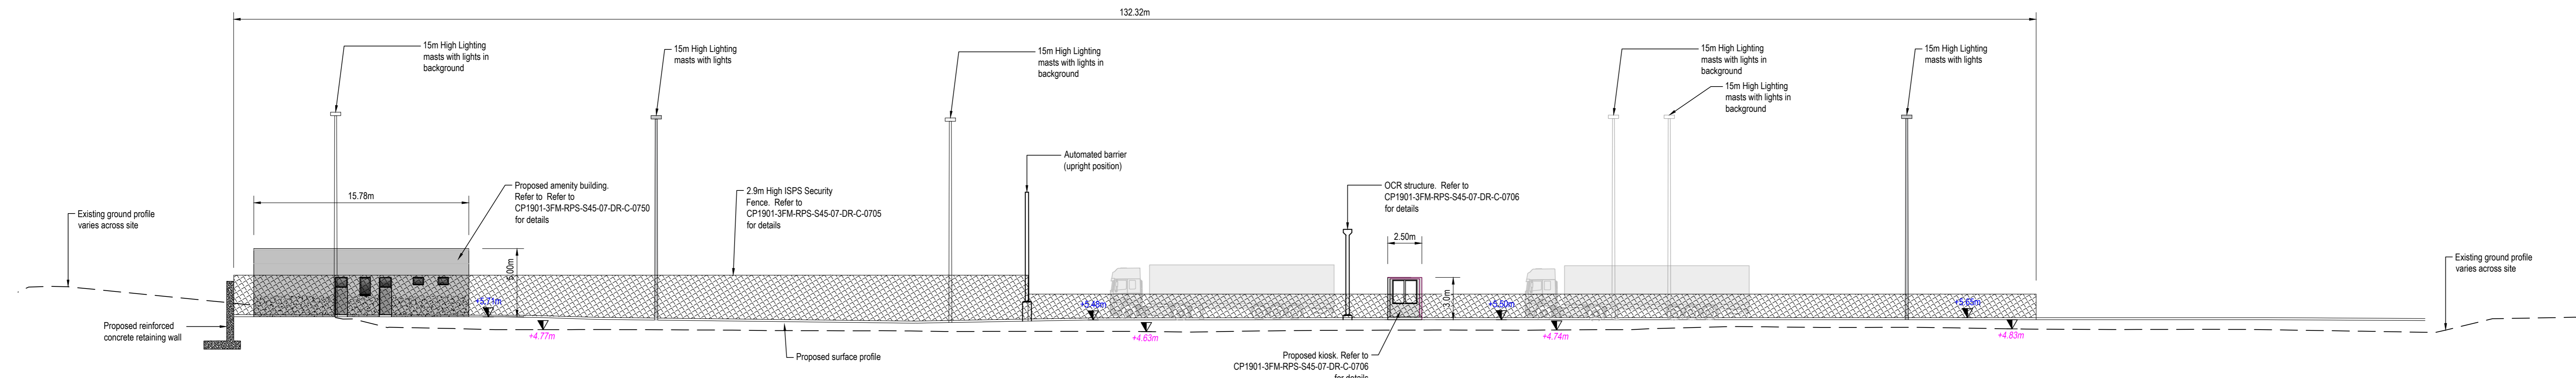

East Elevation [1:200]

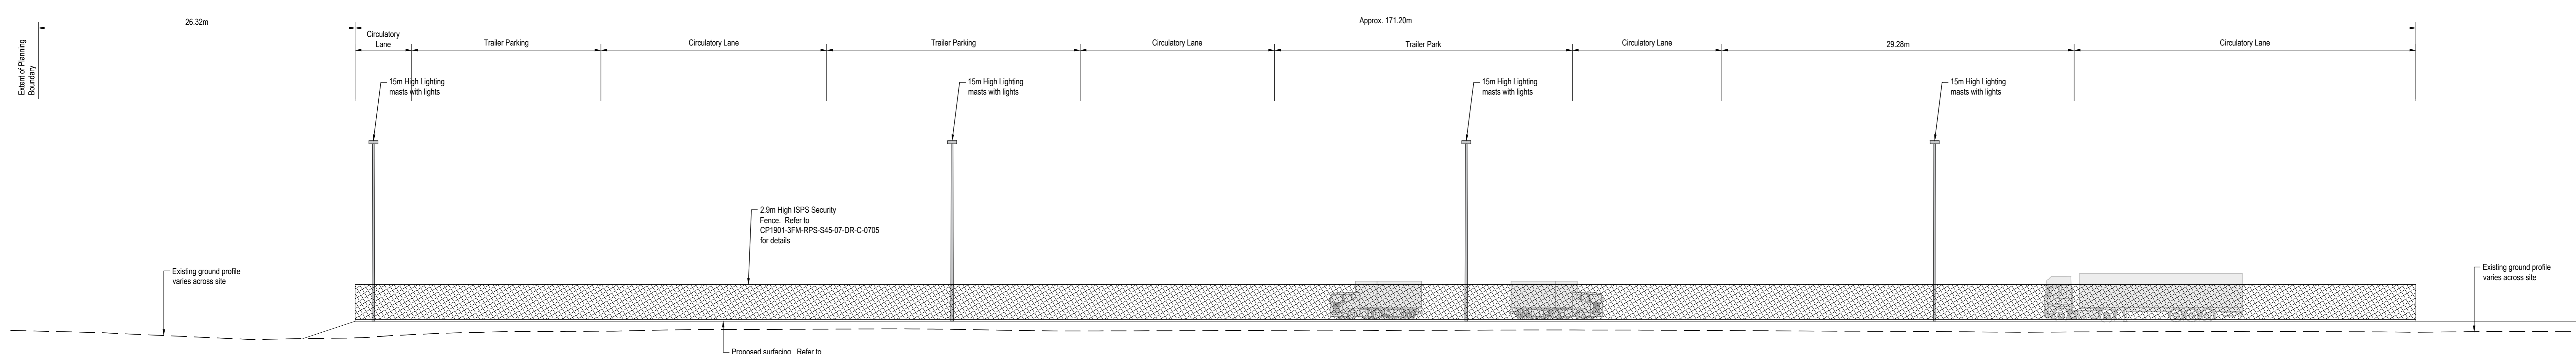

West Elevation [1:200]

P01	Revised for Planning Issue	M.H.	28/06/2024
rev	amendments	check	date

Elmwood House T +44 (0) 28 90 667014
 74 Boucher Road F +44 (0) 28 90 665286
 Belfast W www.rpsgroup.com/ireland
 BT12 6SC E ireland@rpsgroup.com

Client
 COMHLACHT CHALAFORT
 ATHA CLIATH
 DUBLIN PORT COMPANY

Project
 3FMProject Integrating
 building
 to place

Title
 Ro-Ro Terminal Yard (Area O)
 East and West Elevation

Project Number	Sheet Size	Drawing Scale
IBM0842	A0	As Shown

Drawing Number
 CP1901-3FM-RPS-S45-07-DR-C-0710

Drawn By	Status	Revision
M.H.	S4	P01

Checked By	Approved By	Date
B.M.	M.McC.	26/02/2024