


- NOTES**
1. Verifying Dimensions.
The contractor shall verify dimensions against such other drawings or site conditions as pertain to this part of the work.
 2. Existing Services.
Any information concerning the location of existing services indicated on this drawing is intended for general guidance only. It shall be the responsibility of the contractor to determine and verify the exact horizontal and vertical alignment of all cables, pipes, etc. (both underground and overhead) before work commences.
 3. Issue of Drawings.
Hard copies, dwf and pdf will form a controlled issue of the drawing. All other formats (dwg, dxf etc.) are deemed to be an uncontrolled issue and any work carried out based on these files is at the recipient's own risk. RPS will not accept any responsibility for any errors arising from the use of these files, either by human error by the recipient, listing of un-dimensioned measurements, compatibility issues with the recipient's software, and any errors arising when these files are used to aid the recipient's drawing production, or setting out on site.
 4. Datum.
 6. Key

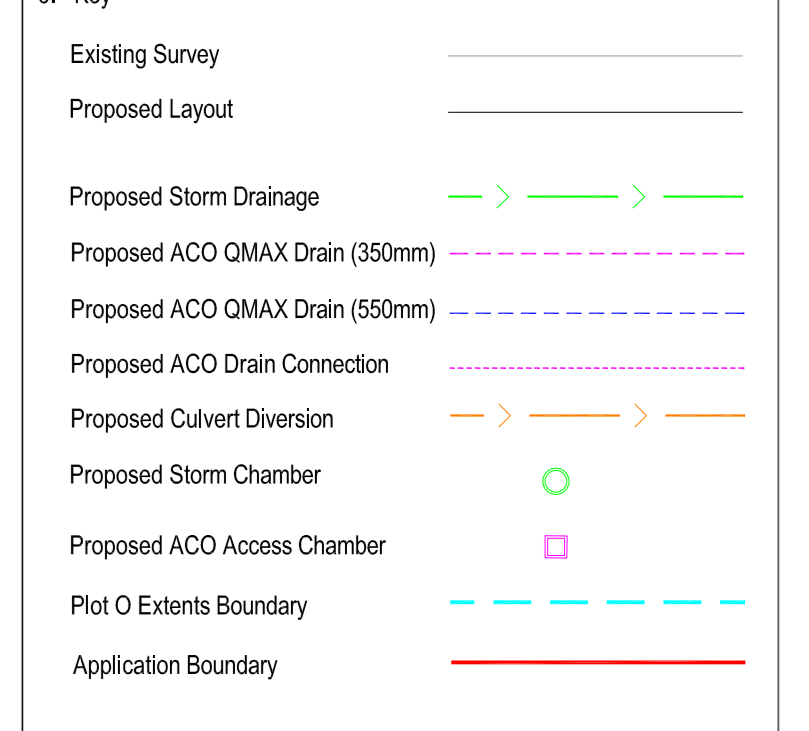


Proposed Port Park Development
Please refer to Drawing Series PPK_TTT_33

Existing Culvert to be intercepted and diverted

Temporary work zone for construction of retaining wall

Culvert diversion to connect to existing Outfall, exact location to be confirmed

Proposed Interceptors Bypass Separation provided for runoff from Area O

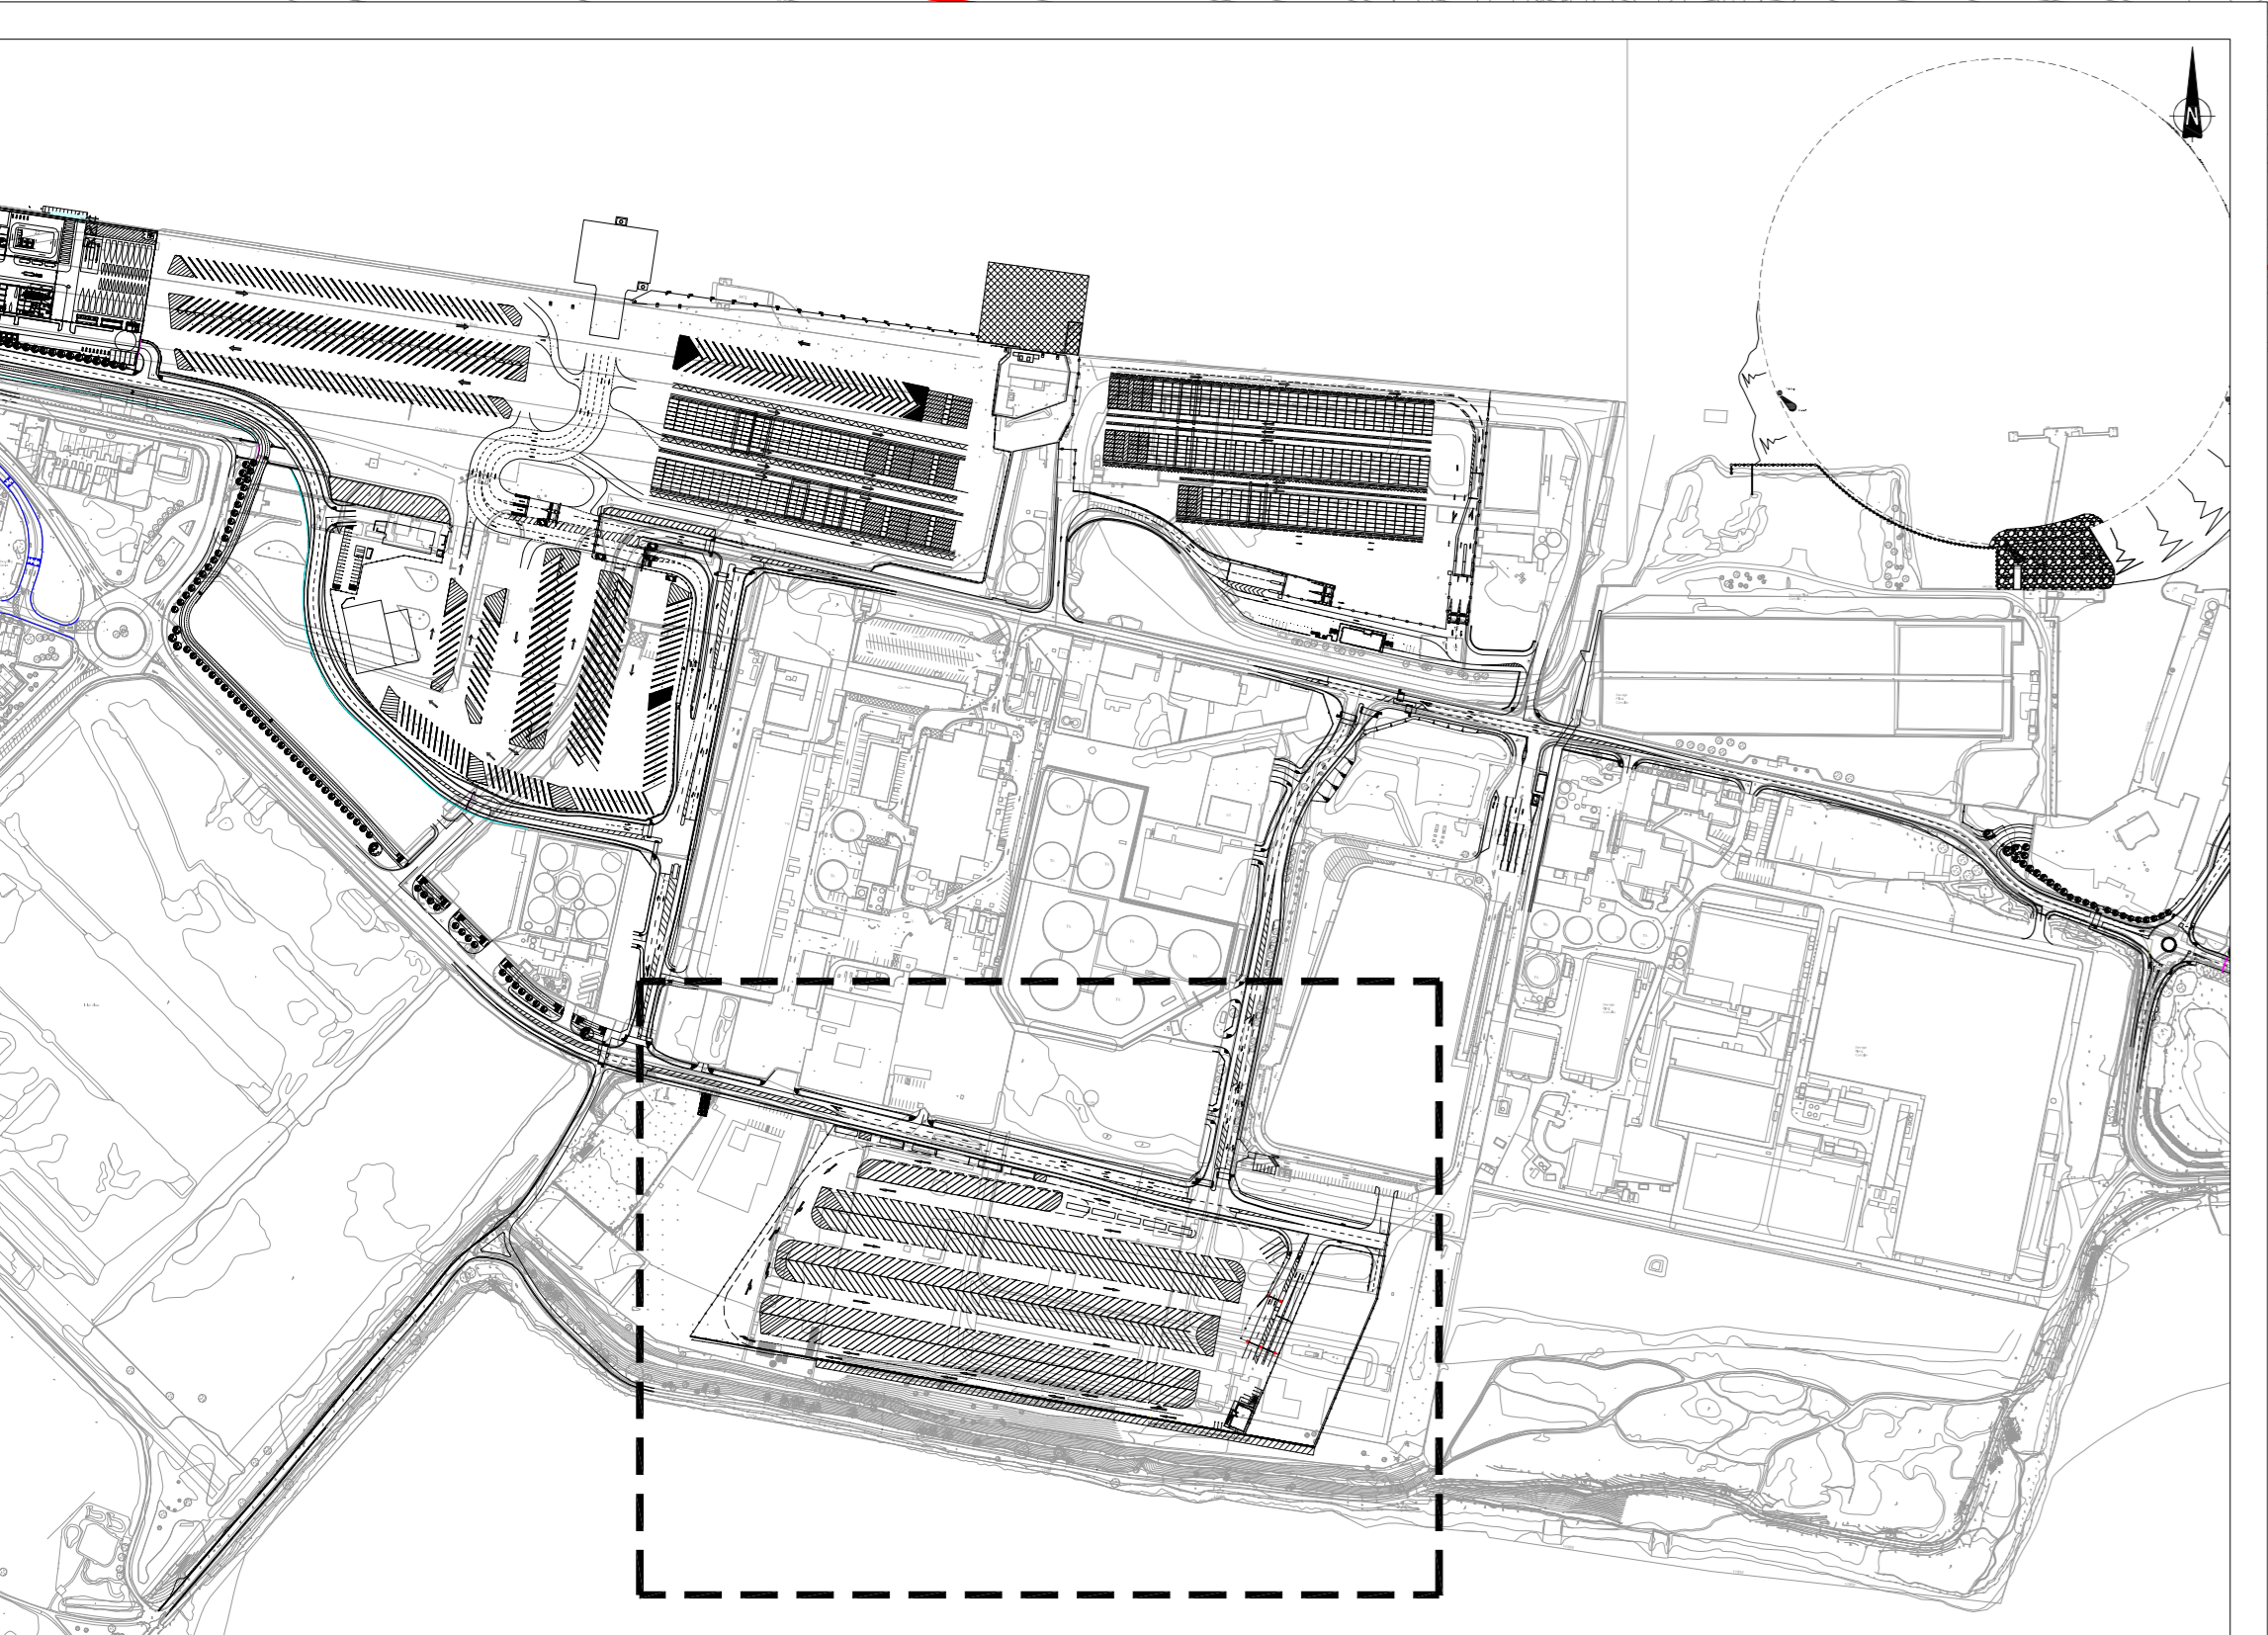

P01	Revised for Planning Submission	SB	June 24
rev	amendments	check	date
<p>Client: COMHLACHT CHALAFORT ATHA CLIATH DUBLIN PORT COMPANY</p>			
<p>Project: 3FMProject</p>			
<p>Title: Ro-Ro Terminal Yard (Area O) Proposed Drainage Layout</p>			
Project Number	Sheet Size	Drawing Scale	
IBH0796	A1	1:500	
Drawing Number			
CP1901-3FM-RPS-S45-07-DR-C-0744			
Drawn By	Status	Revision	
DMI	S4	P01	
Checked By	Approved By	Date	
PN	CDo	Dec 2022	