
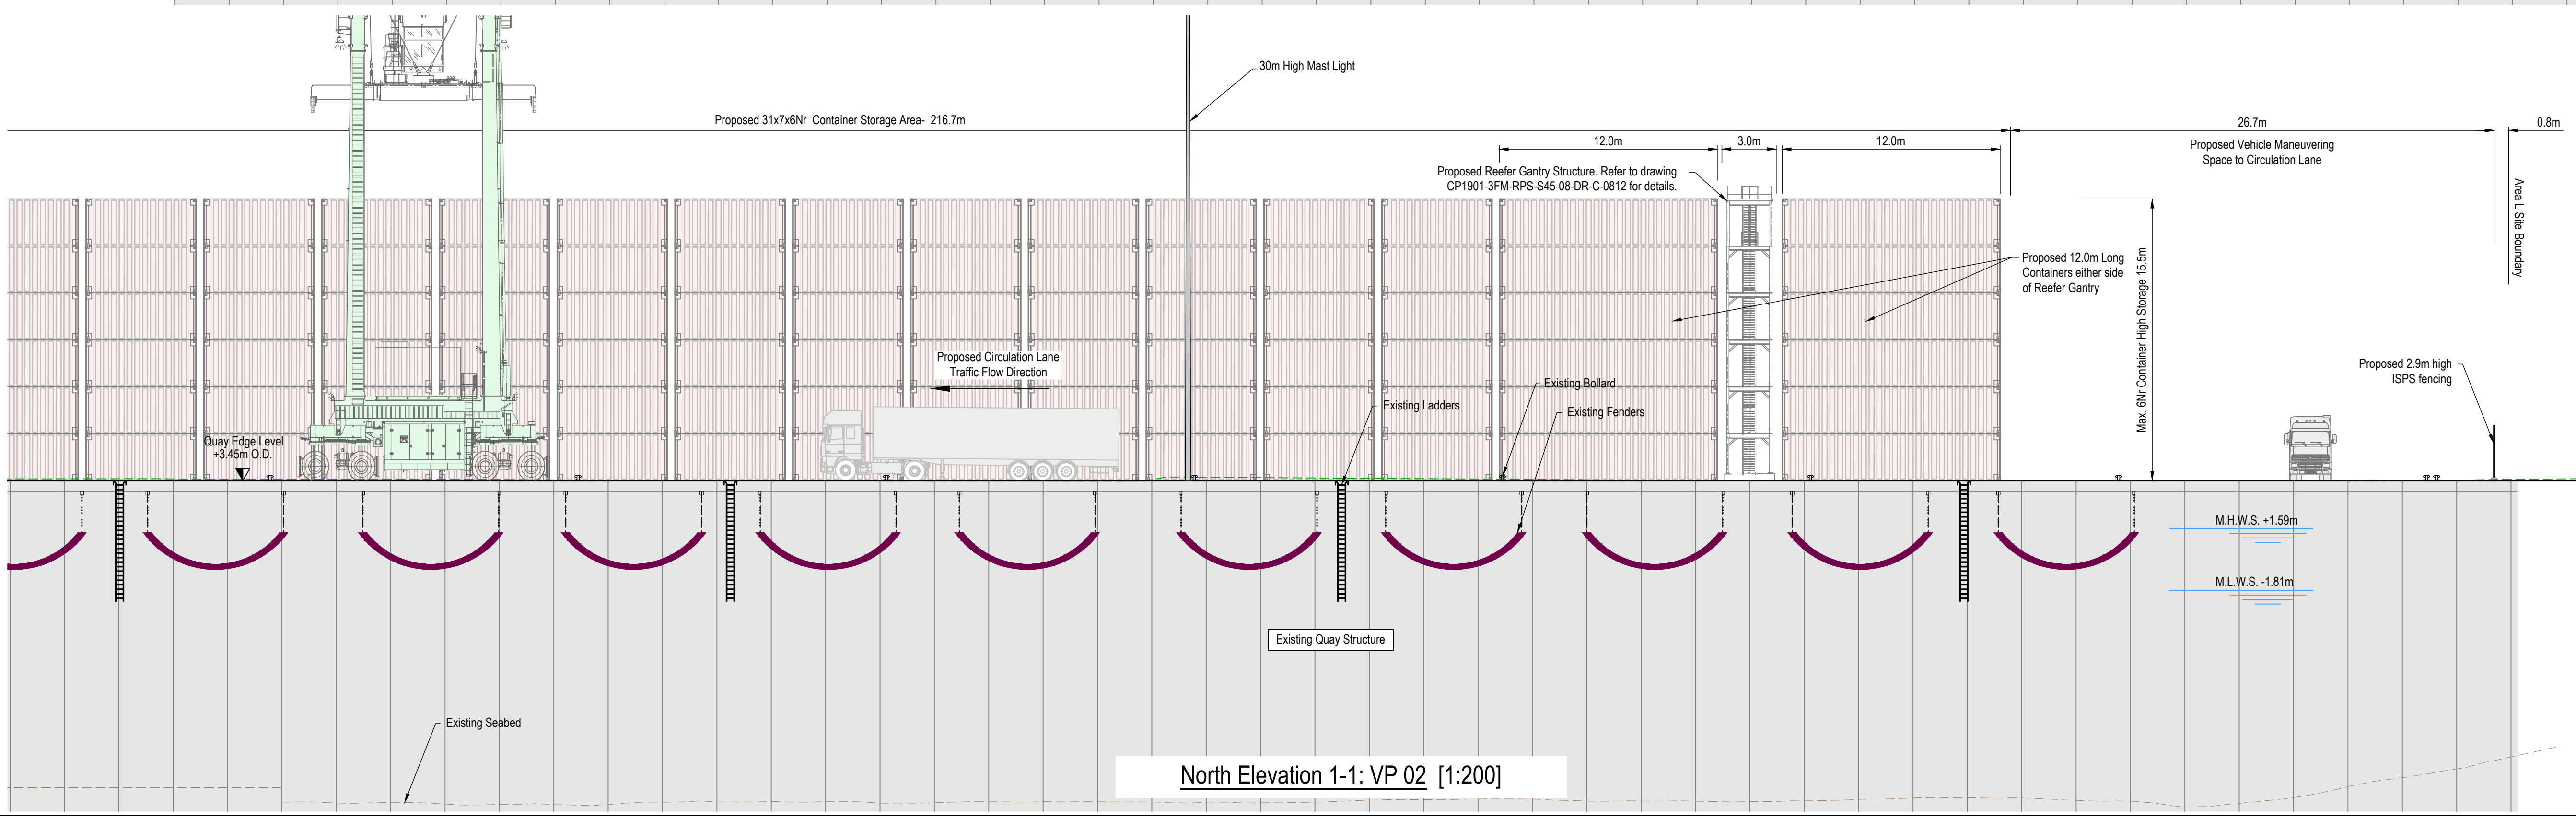


- NOTES**
1. Verifying Dimensions. Dimensions shall be verified against such other drawings or site conditions as pertain to this part of the work.
  2. Existing Services. Any information concerning the location of existing services indicated on this drawing is intended for general guidance only.
  3. Datum. Ordnance Datum Malin (unless noted otherwise)
  4. CWP refers to Coding Wind Park. OD refers to Ordnance Datum Malin. eRMG refers to Electric Rail Mounted Gantry Crane
  5. Section and elevation locations CP1901-3FM-RPS-S45-07-DR-C-0801
  6. Refer to CP1901-3FM-RPS-S45-06-DR-C-0809 for Drainage Layout
  7. Refer to CP1901-3FM-RPS-S45-06-DR-C-0808 for Surface Levels
  8. Refer to CP1901-3FM-RPS-S45-06-DR-C-0807 for Construction Surface Makeup

**Key**

- Existing Shore Side Surface Profile
- Existing River Bed Profile
- Proposed Finished Surface Profile

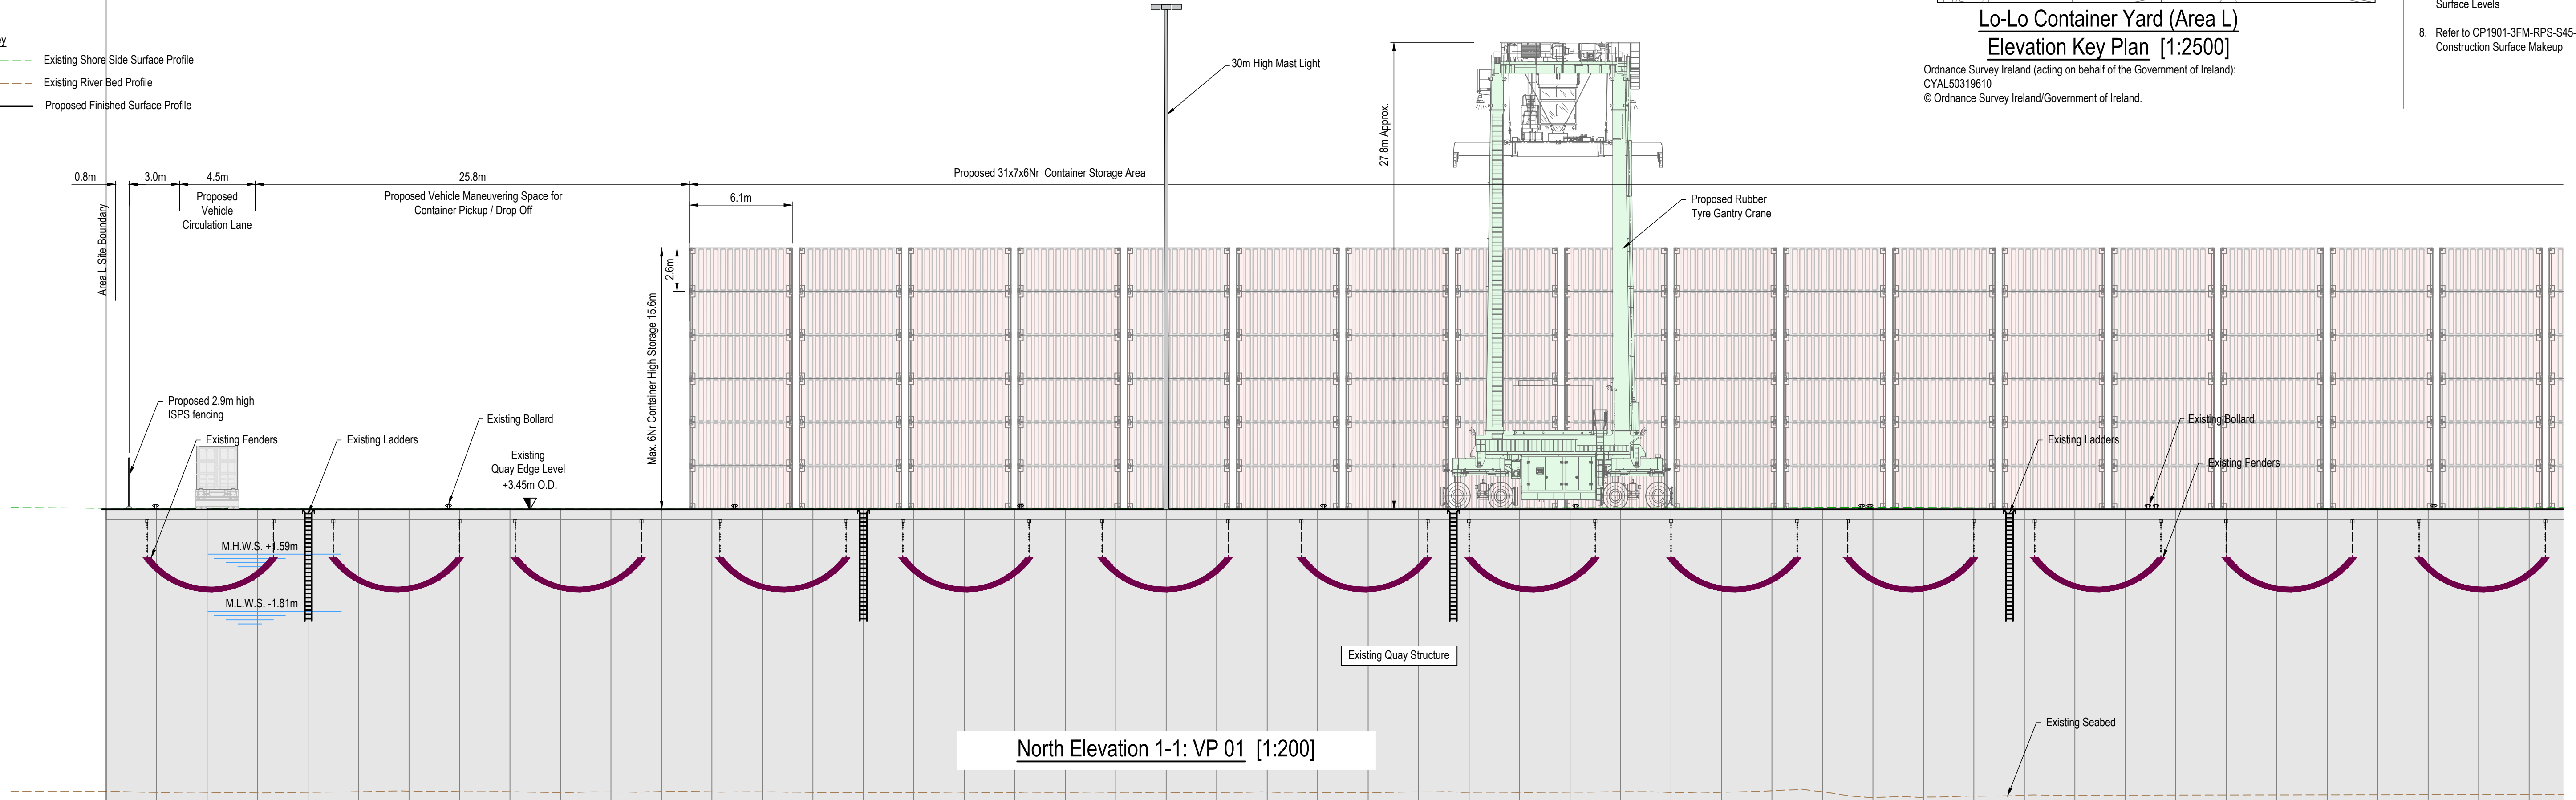

P05	Revised for Planning Issue	M.H.	30/06/2024
rev	amendments	check	date
		Elmwood House 74 Boucher Road Belfast BT12 6RZ T +44 (0) 28 90 667914 F +44 (0) 28 90 668286 W www.rpsgroup.com/ireland E ireland@rpsgroup.com	
Client			
Project			
Title			
Lo-Lo Container Yard (Area L) Proposed North Elevation			
Project Number	Sheet Size	Drawing Scale	
IBM0842	A1	As Shown	
Drawing Number			
CP1901-3FM-RPS-S45-08-DR-C-0806			
Drawn By	Status	Revision	
J.R.	S4	P05	
Checked By	Approved By	Date	
B.M.	M.McC.	26/02/2024	