




NOTES:

- THIS DRAWING IS TO BE READ IN CONJUNCTION WITH ALL RELEVANT ENGINEER'S AND ARCHITECT'S DRAWINGS, SPECIFICATIONS AND DESIGNER'S RISK ASSESSMENTS.
- ALL LEVELS ARE IN METRES TO ORDNANCE DATUM, MALIN HEAD.
- THE TOPOGRAPHICAL INFORMATION IS REPLICATED FROM INFORMATION RECEIVED FROM OTHERS AND IS ISSUED AS BACKGROUND INFORMATION ONLY.

LEGEND:

- PROPOSED SURFACE WATER DRAIN
- PROPOSED FOUL WATER DRAIN
- PROPOSED GULLY
- PROPOSED ACO CHANNEL
- PROPOSED SWALE
- EXISTING SURFACE WATER SEWER/ DRAIN
- EXISTING FOUL WATER SEWER/ DRAIN
- PROPOSED FUEL LINE
- PROPOSED BUILDING
- LANDSCAPE (REFER TO LANDSCAPE ARCHITECT'S DRAWINGS FOR DETAILS)
- PROPOSED ROAD
- PROPOSED FOOTPATH
- PROPOSED PUBLIC SPACE (REFER TO LANDSCAPE ARCHITECT'S DRAWINGS FOR DETAILS)
- PROPOSED PERMEABLE PAVING
- PROPOSED WALL

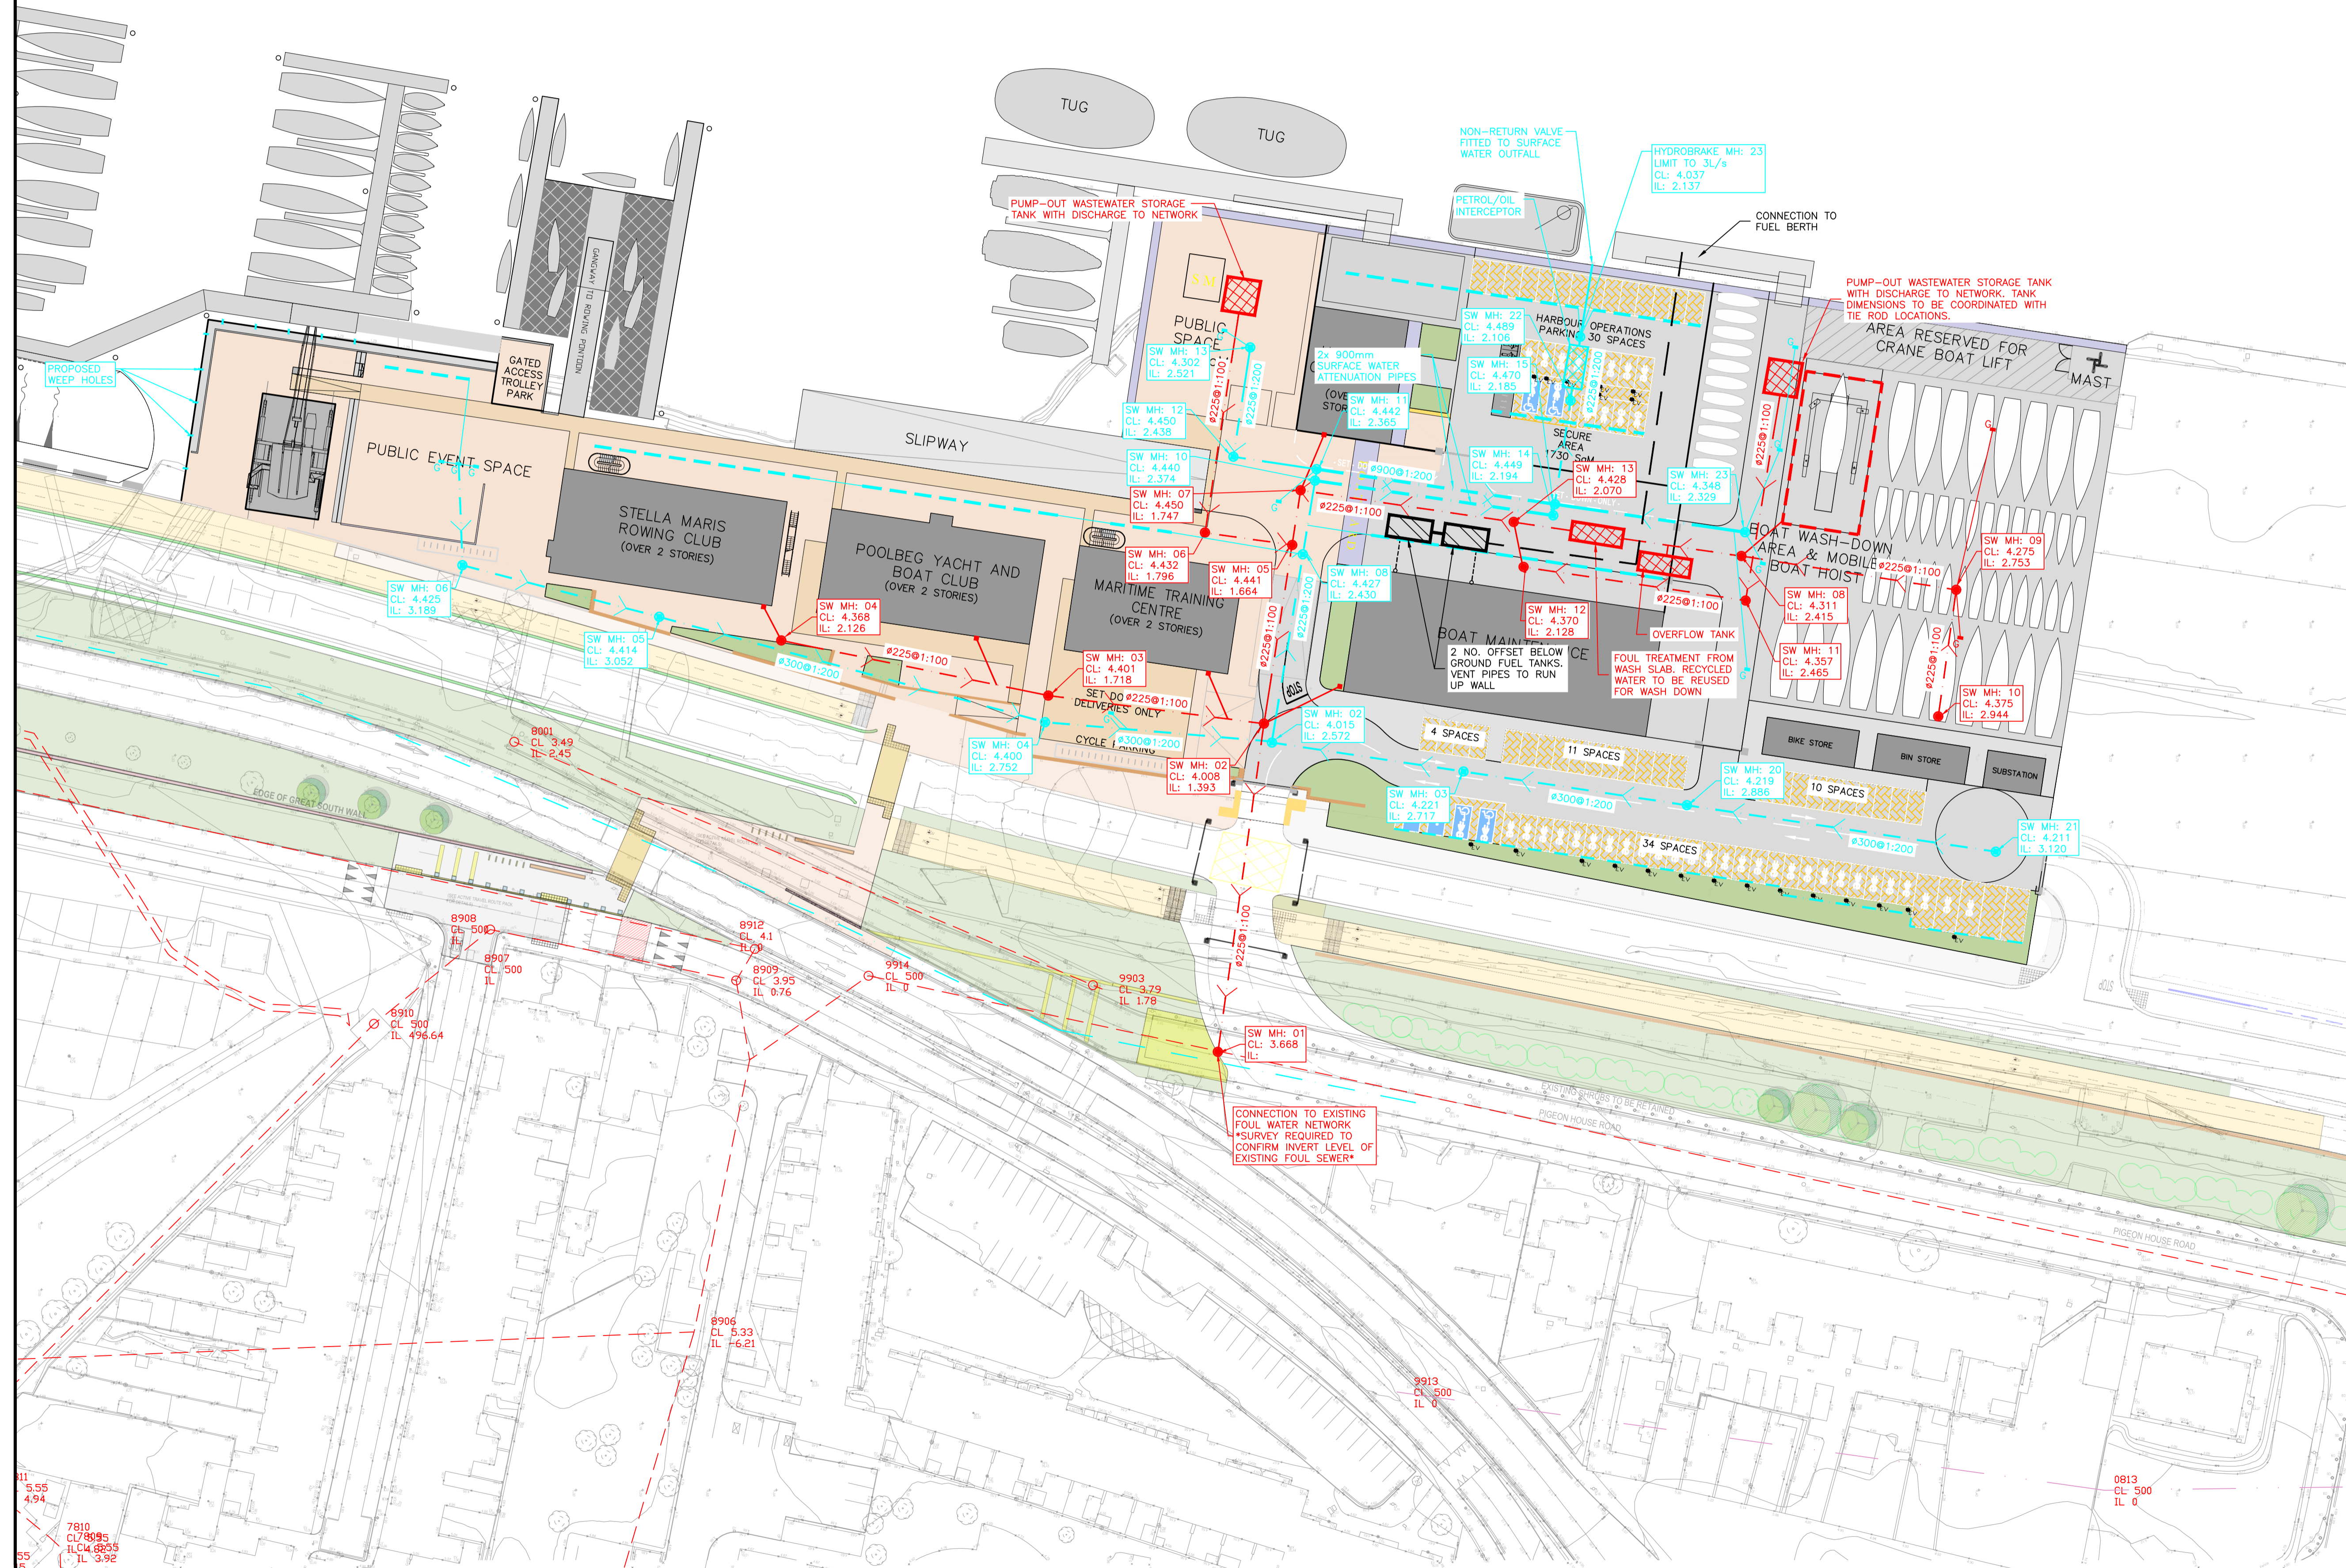

No.		Revision		Date	By	Chkd	App'd
P01	ISSUE FOR PLANNING			28/06/24	LW	SK	BDG
PLANNING							
Offices: Dublin - Sandycroft & Santry Leeds - Otley Ireland 1+353 (0) 1 294 0800 UK 1+44 (0) 113 360 1720							
Client: DUBLIN PORT COMPANY							
Project Title: 3FM PROJECT							
Drawing Title: MARITIME VILLAGE: PROPOSED DRAINAGE LAYOUT							
Drawing Number: CP1901_010-ROD-00-XX-DR-C-0031		Rev: P01		Scale: 1:500@A1		Date: MAR23	
Drawn: LW		Checked: SK		Approved: BDG		Job No: 22.149	
Status Code: S5 - FOR REVIEW & ACCEPTANCE							