

Area of Shelly Banks Road to be served by existing drainage system

Existing Culvert to be intercepted and diverted

NOTES

- Verifying Dimensions.**
The contractor shall verify dimensions against such other drawings or site conditions as pertain to this part of the work.
- Existing Services.**
Any information concerning the location of existing services indicated on this drawing is intended for general guidance only. It shall be the responsibility of the contractor to determine and verify the exact horizontal and vertical alignment of all cables, pipes, etc. (both underground and overhead) before work commences.
- Issue of Drawings.**
Hard copies, dxf and pdf will form a controlled issue of the drawing. All other formats (dwg, dxf etc.) are deemed to be an uncontrolled issue and any work carried out based on these files is at the recipient's own risk. RPS will not accept any responsibility for any errors arising from the use of these files, either by human error by the recipient, listing of un-dimensioned measurements, compatibility issues with the recipient's software, and any errors arising when these files are used to aid the recipient's drawing production, or setting out on site.
- OS Map Sheet No**
3198-13, 3198-14, 3198-15, 3198-18, 3198-19, 3198-20, 3198-23, 3198-24, 3198-25, 3264-03, 3264-04, 3264-05, 3264-08, 3264-09, 3264-10, 3264-13, 3264-14, 3264-15, 3264-18, 3264-19, 3264-20, 3199-11, 3199-12, 3199-13, 3199-14, 3199-15, 3199-16, 3199-17, 3199-18, 3199-19, 3199-21, 3199-22, 3199-23, 3199-24, 3265-01, 3265-02, 3265-03, 3265-04, 3265-06, 3265-07, 3265-08, 3265-09, 3265-10, 3265-11, 3265-12, 3265-16
- Datum.** ITM

Existing Survey	
Proposed Layout	
Proposed Earthworks	
Application Boundary	
Proposed Security Barrier	
Proposed bridge spine beam	
Special Areas of Conservation Boundary	
Special Protection Areas Boundary	
Drainage Key	
Proposed Storm Drainage	
Proposed Filter Drain	
Proposed ACO QMAX Drain (225mm)	
Proposed ACO QMAX Drain (350mm)	
Proposed ACO QMAX Drain (550mm)	
Proposed ACO Drain Connection	
Proposed Culvert Diversion	
Proposed Gully Connection	
Proposed Building Storm Connection	
Proposed Drainage Kerb	
Proposed Gully	
Relocated Gully	
Proposed Storm Chamber	
Proposed ACO Access Chamber	
Proposed Hydrobrake Flow Control	
Proposed Petrol Interceptor	
Proposed Building Down Pipe	
Proposed Filter Drain Chamber	

Existing Services
The proposed designs have been developed to minimise impact on existing and permitted services/utility infrastructure. Any protection or diversionary works required will be developed and agreed with the relevant public utility companies during detailed design stage

P02	Revised for Planning submission	CD	27/06/24
P01	Revised for planning	PN	02/10/23
rev	amendments	check	date

rps Elmwood House
74 Boucher Road
Belfast
BT12 6RZ
T +44 (0) 28 90 667914
F +44 (0) 28 90 668286
W www.rpsgroup.com/ireland
E ireland@rpsgroup.com

Client
**COMHLACHT CHALAFORT
ATHA CLIATH
DUBLIN PORT COMPANY**

Project
3FMProject Bringing Dublin Port To 2040


Title
**Roads & Footways (Southern & SPAR) -
Proposed Storm Drainage Layout
Sheet 10**

Project Number	Sheet Size	Drawing Scale
IBH0796	A1	1:500

Drawing Number
CP1901_3FM-RPS_S26-HDG-XX-DR-D-500-0011

Drawn By	Status	Revision
PA	S4	P02

Checked By	Approved By	Date
PN	CD	22/06/2023

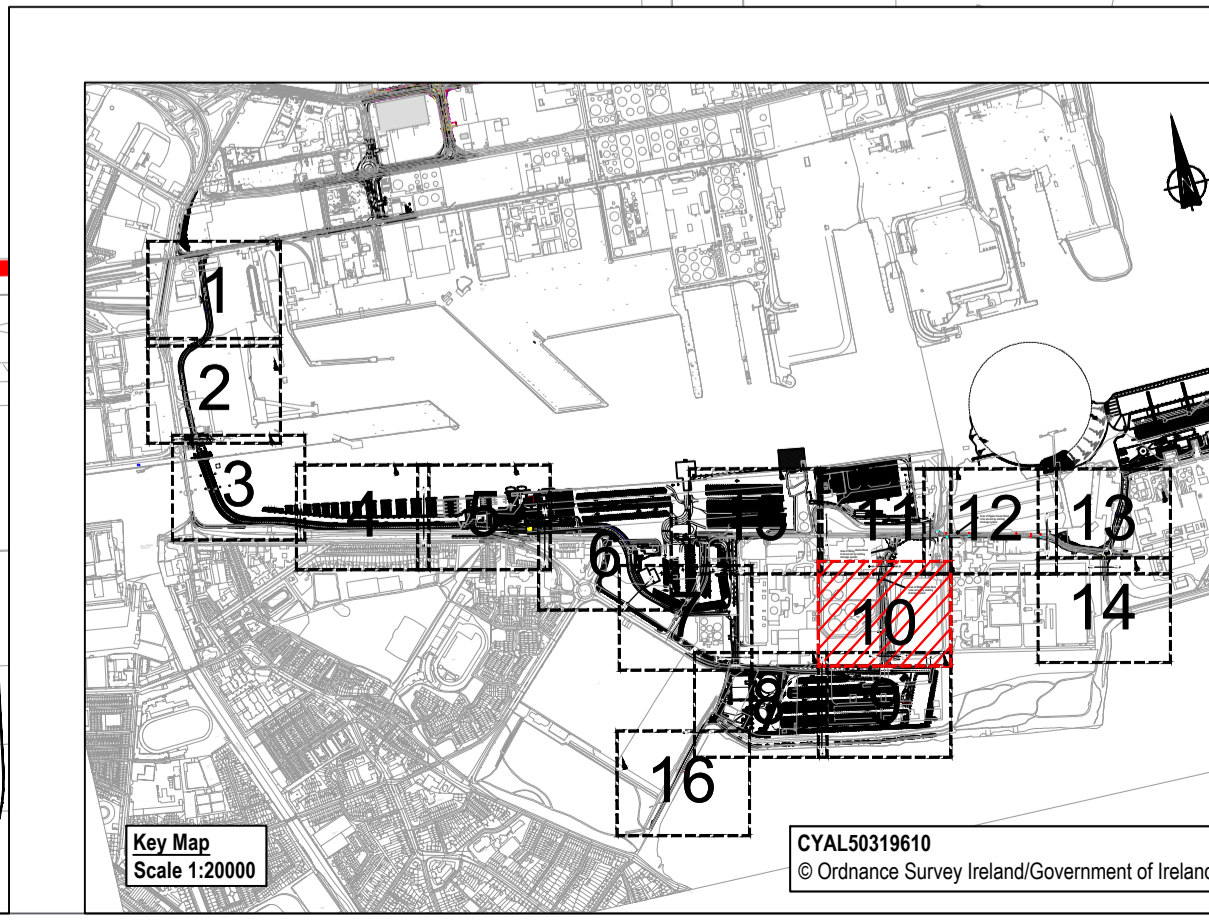

Key Map
Scale 1:20000
CYAL50319610
© Ordnance Survey Ireland/Government of Ireland.